



S. HIGHLAND AVENUE

PARKING  
GARAGE

# LIGHTING LEGEND

- R ROADWAY LIGHTING
- ES RELOCATE EXISTING STREET LIGHTING
- S STREET LIGHTING
- O ORNAMENTAL LIGHTING
- N NICHE LIGHTING
- W WALL WASH LIGHTING
- ▲▲ TREE UPLIGHTING

W. CAMPBELL STREET

225 W.  
CAMPBELL

44 S.  
HIGHLAND

COURTYARD  
LIGHTING


225 W.  
CAMPBELL

33 S.  
CHESTNUT

S. CHESTNUT AVENUE




## Lighting Plan Arlington 425 Arlington Heights, Illinois

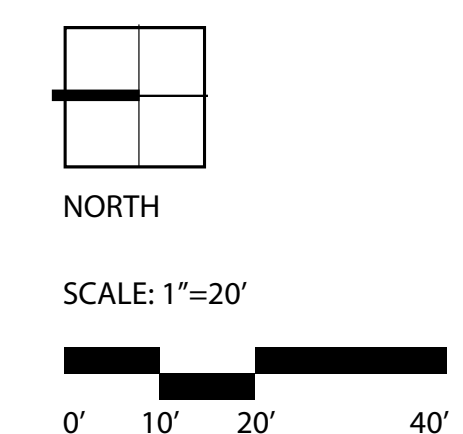

ISSUE DATE: March 14, 2019  
All drawings are preliminary and subject to change.  
© 2019 Hitchcock Design Group

PREPARED FOR:  
CCH LLC



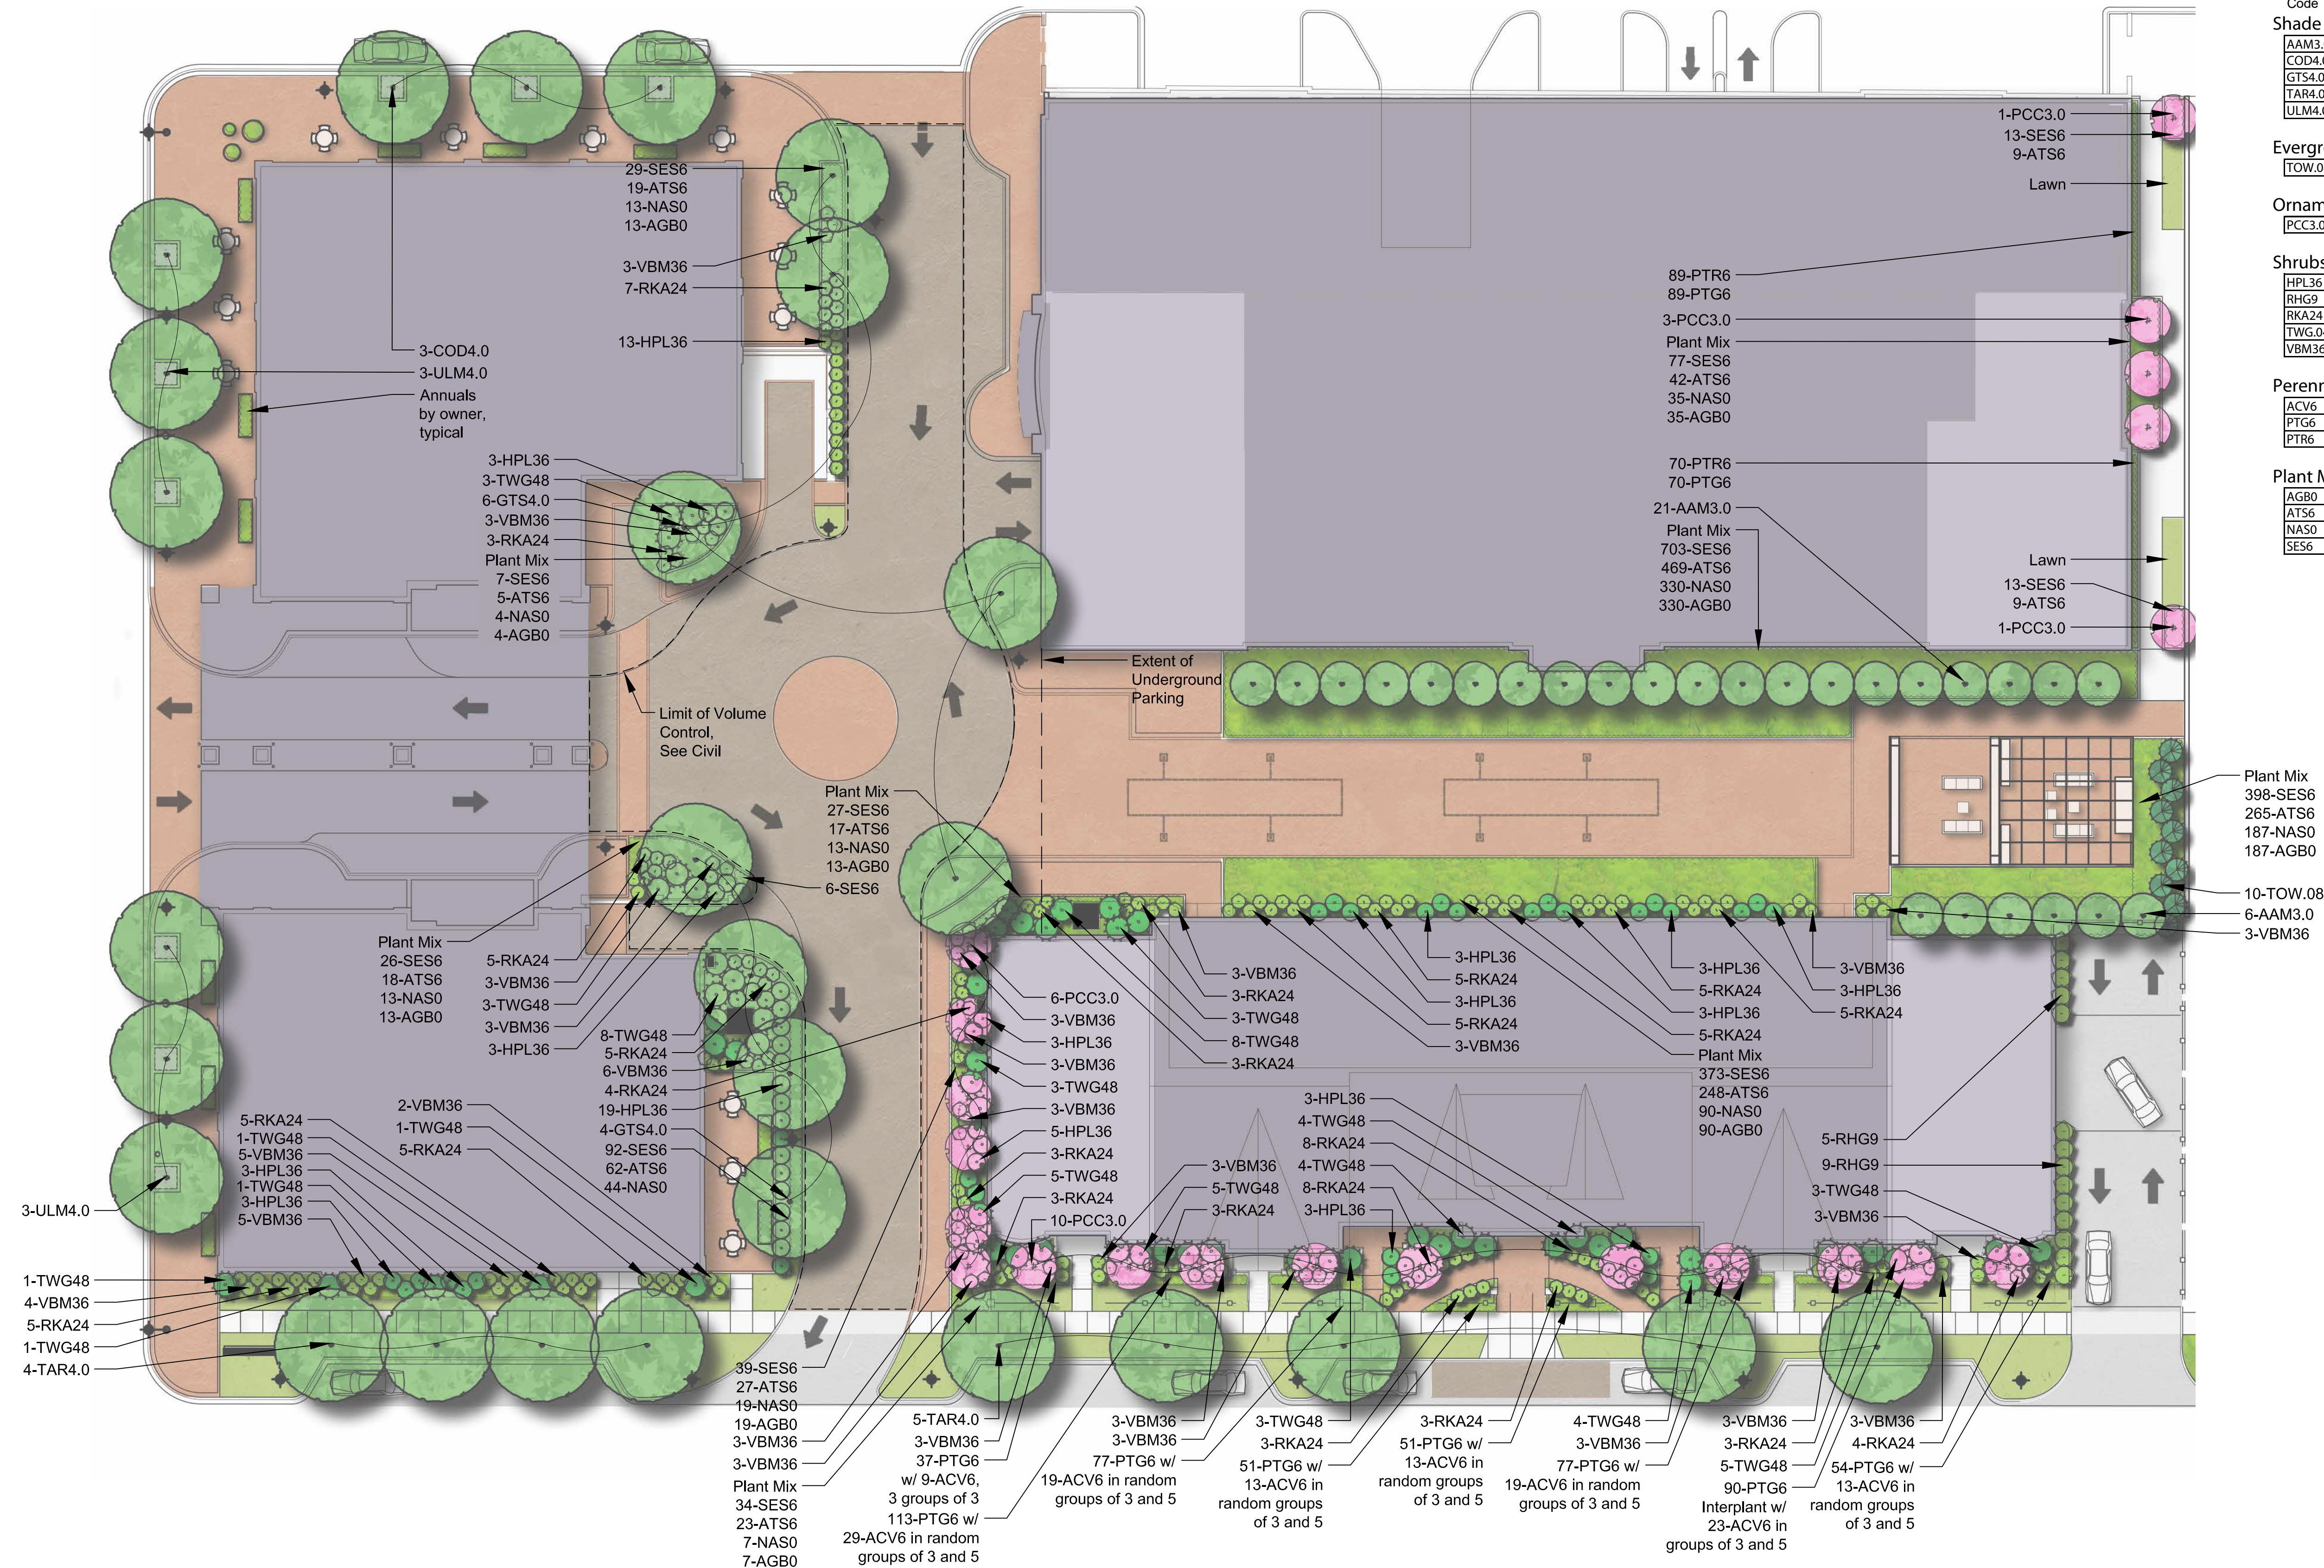

Code	Botanical Name	Common Name	Size	Qty	Notes
<b>Shade Trees</b>					
AAM3.0	Acer x freemanii 'Armstrong'	Armstrong Red Maple	3" C	27	
CD04.0	Celtis occidentalis	Common Hackberry	4" C	3	
GT54.0	Gleditsia triacanthos var. inermis	Shademaker Honeylocust	4" C	10	
TAR4.0	Tilia americana 'Redmond'	Redmond American Linden	4" C	9	
ULM4.0	Ulmus japonica x wilsoniana 'Morton'	Accolade Elm	4" C	6	

Evergreen Trees					
TOW.08	Thuja occidentalis 'Hetz Wintergreen'	Wintergreen Eastern Arborvitae	8' HT	10	


Ornamental Trees					
PCC3.0	Pyrus calleryana 'Chanticleer'	Chanticleer Callery Pear	3" C	21	

Shrubs						
HPL36	Hydrangea paniculata 'Jane'	Little Lime Hydrangea	36" HT	73	Per plan	
RHG9	Rhus aromatica 'Gro-Low'	Gro-Low Fragrant Sumac	5 GAL	14	Per plan	
RKA24	Rhododendron x Karen	Karen Gable Hybrid Azalea	24" HT	108	Per plan	
TWG.04	Thuja occidentalis 'Woodwardii'	Woodward Globe Arborvitae	4" HT	66	Per plan	
VBM36	Viburnum carlesii 'compactum'	Koreanspice viburnum	24" HT	85	Per plan	

Perennials					
ACV6	Astilbe chinensis 'Vision in White'	Green in White Astilbe	1 GAL	138	18" O.C.
PTG6	Pachysandra terminalis 'Green Carpet'	Green Carpet Chinese Pachysandra	1 GAL	709	12" O.C.
PTR6	Parthenocissus tricuspidata	Boston Ivy	1 GAL	159	12" O.C.


Plant Mix						
AG80	Allium 'Globemaster'	Globemaster Flowering Onion	BULB	721	24" O.C.	
AT56	Allium tanguticum 'Summer Beauty'	Summer Beauty Ornamental Chive	1 GAL	1227	40% @ 18" O.C.	
NA50	Narcissus 'All Spring Mix'	All Spring' Daffodil Mix	BULB	765	24" O.C.	
SE56	Sesleria autumnalis	Autumn Moor Grass	1 GAL	1859	60% @ 18" O.C.	



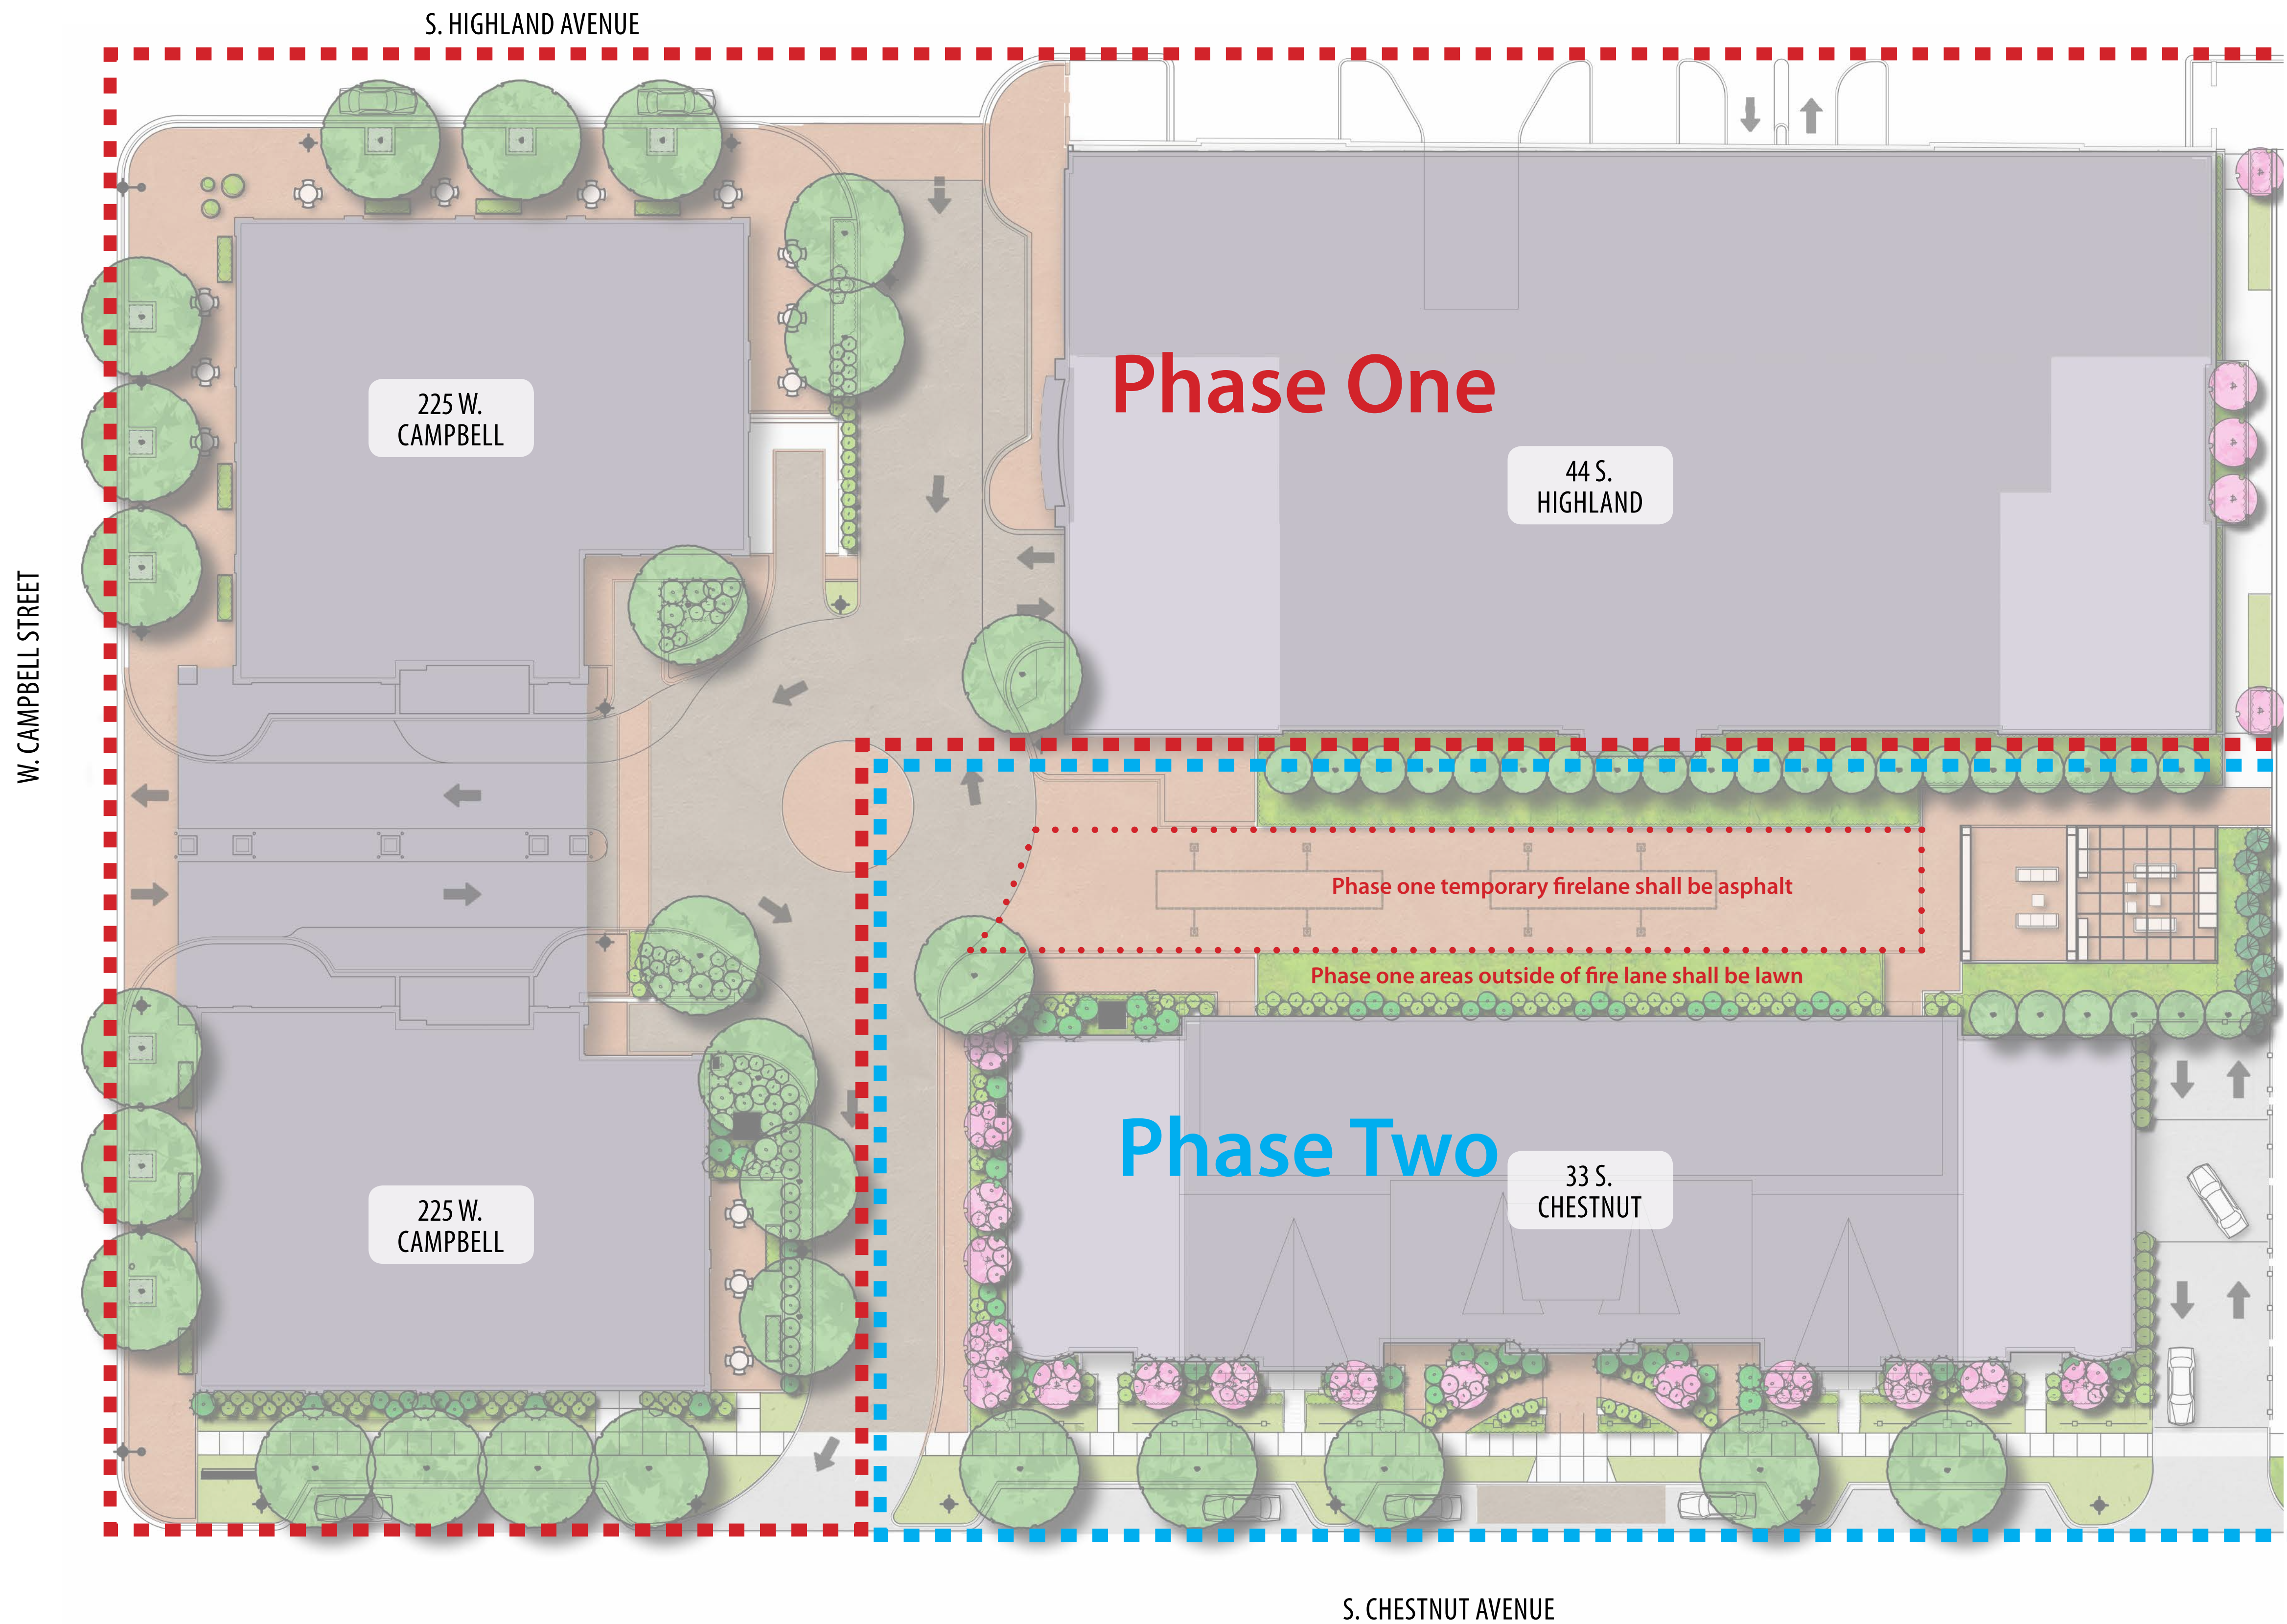





# In Progress Details Included For Reference Only

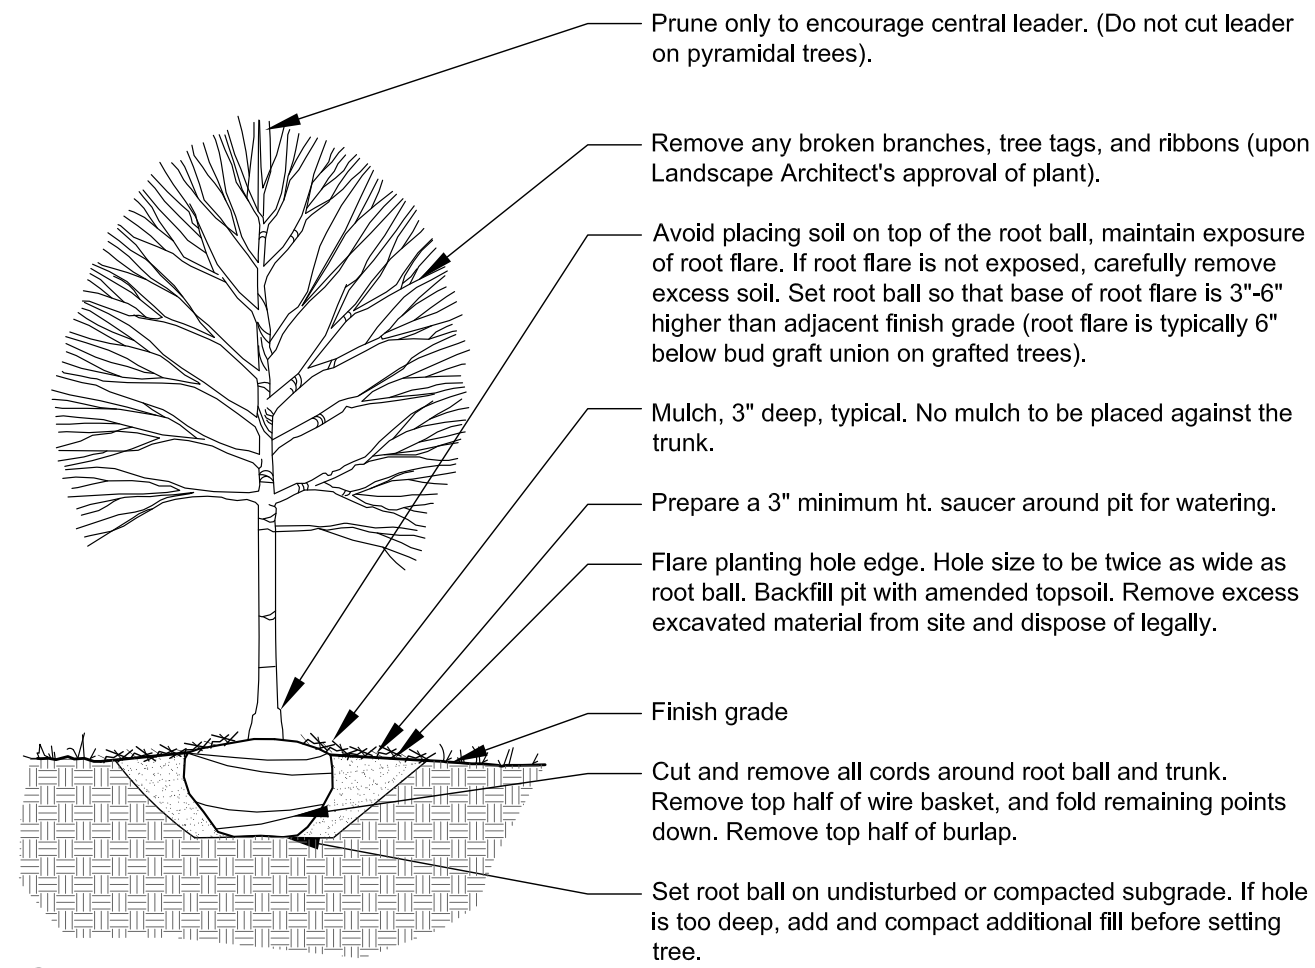


1 Shade Tree Planting

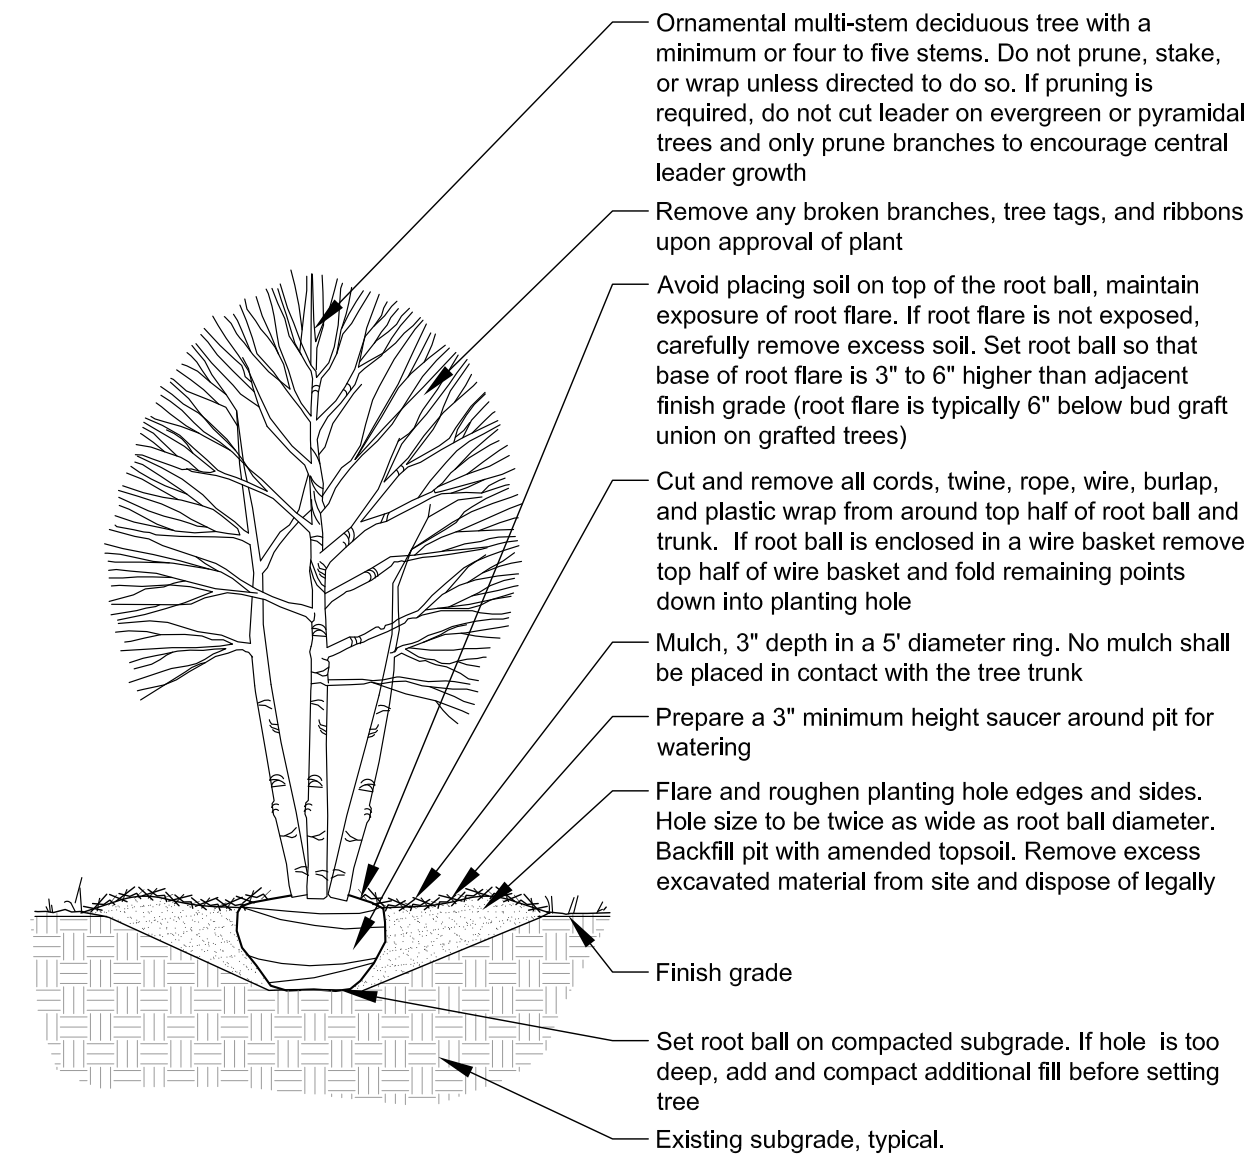


2 Ornamental Tree Planting

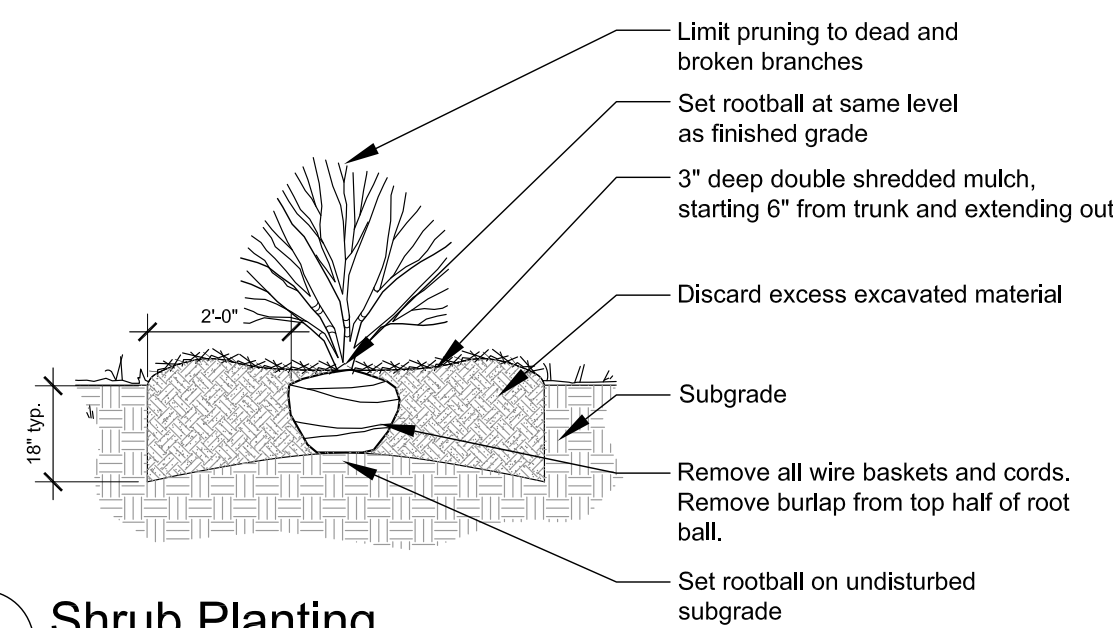


3 Shrub Planting

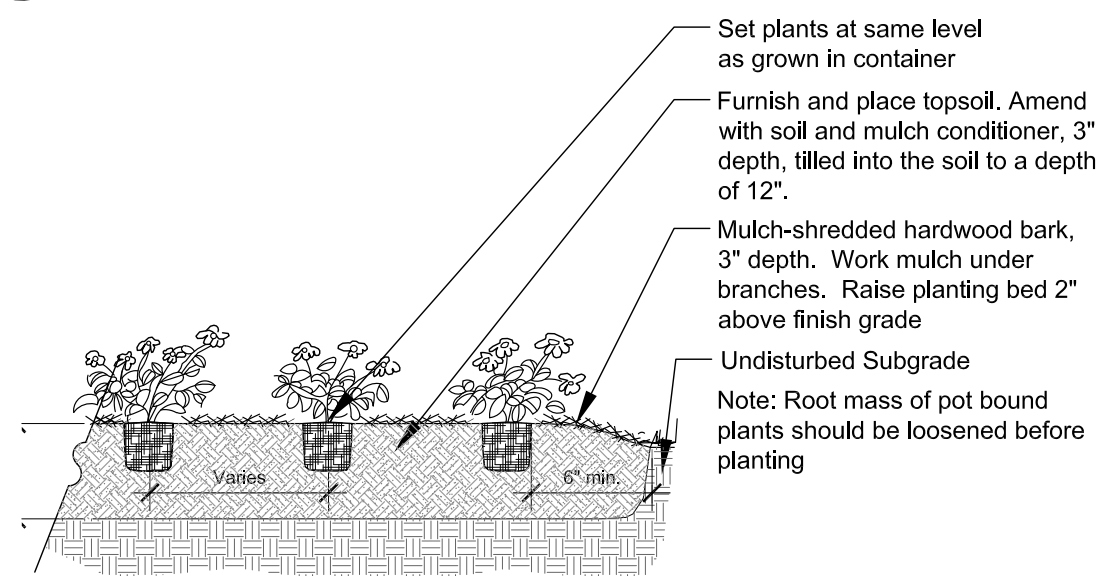

4 Perennial And Groundcover Planting

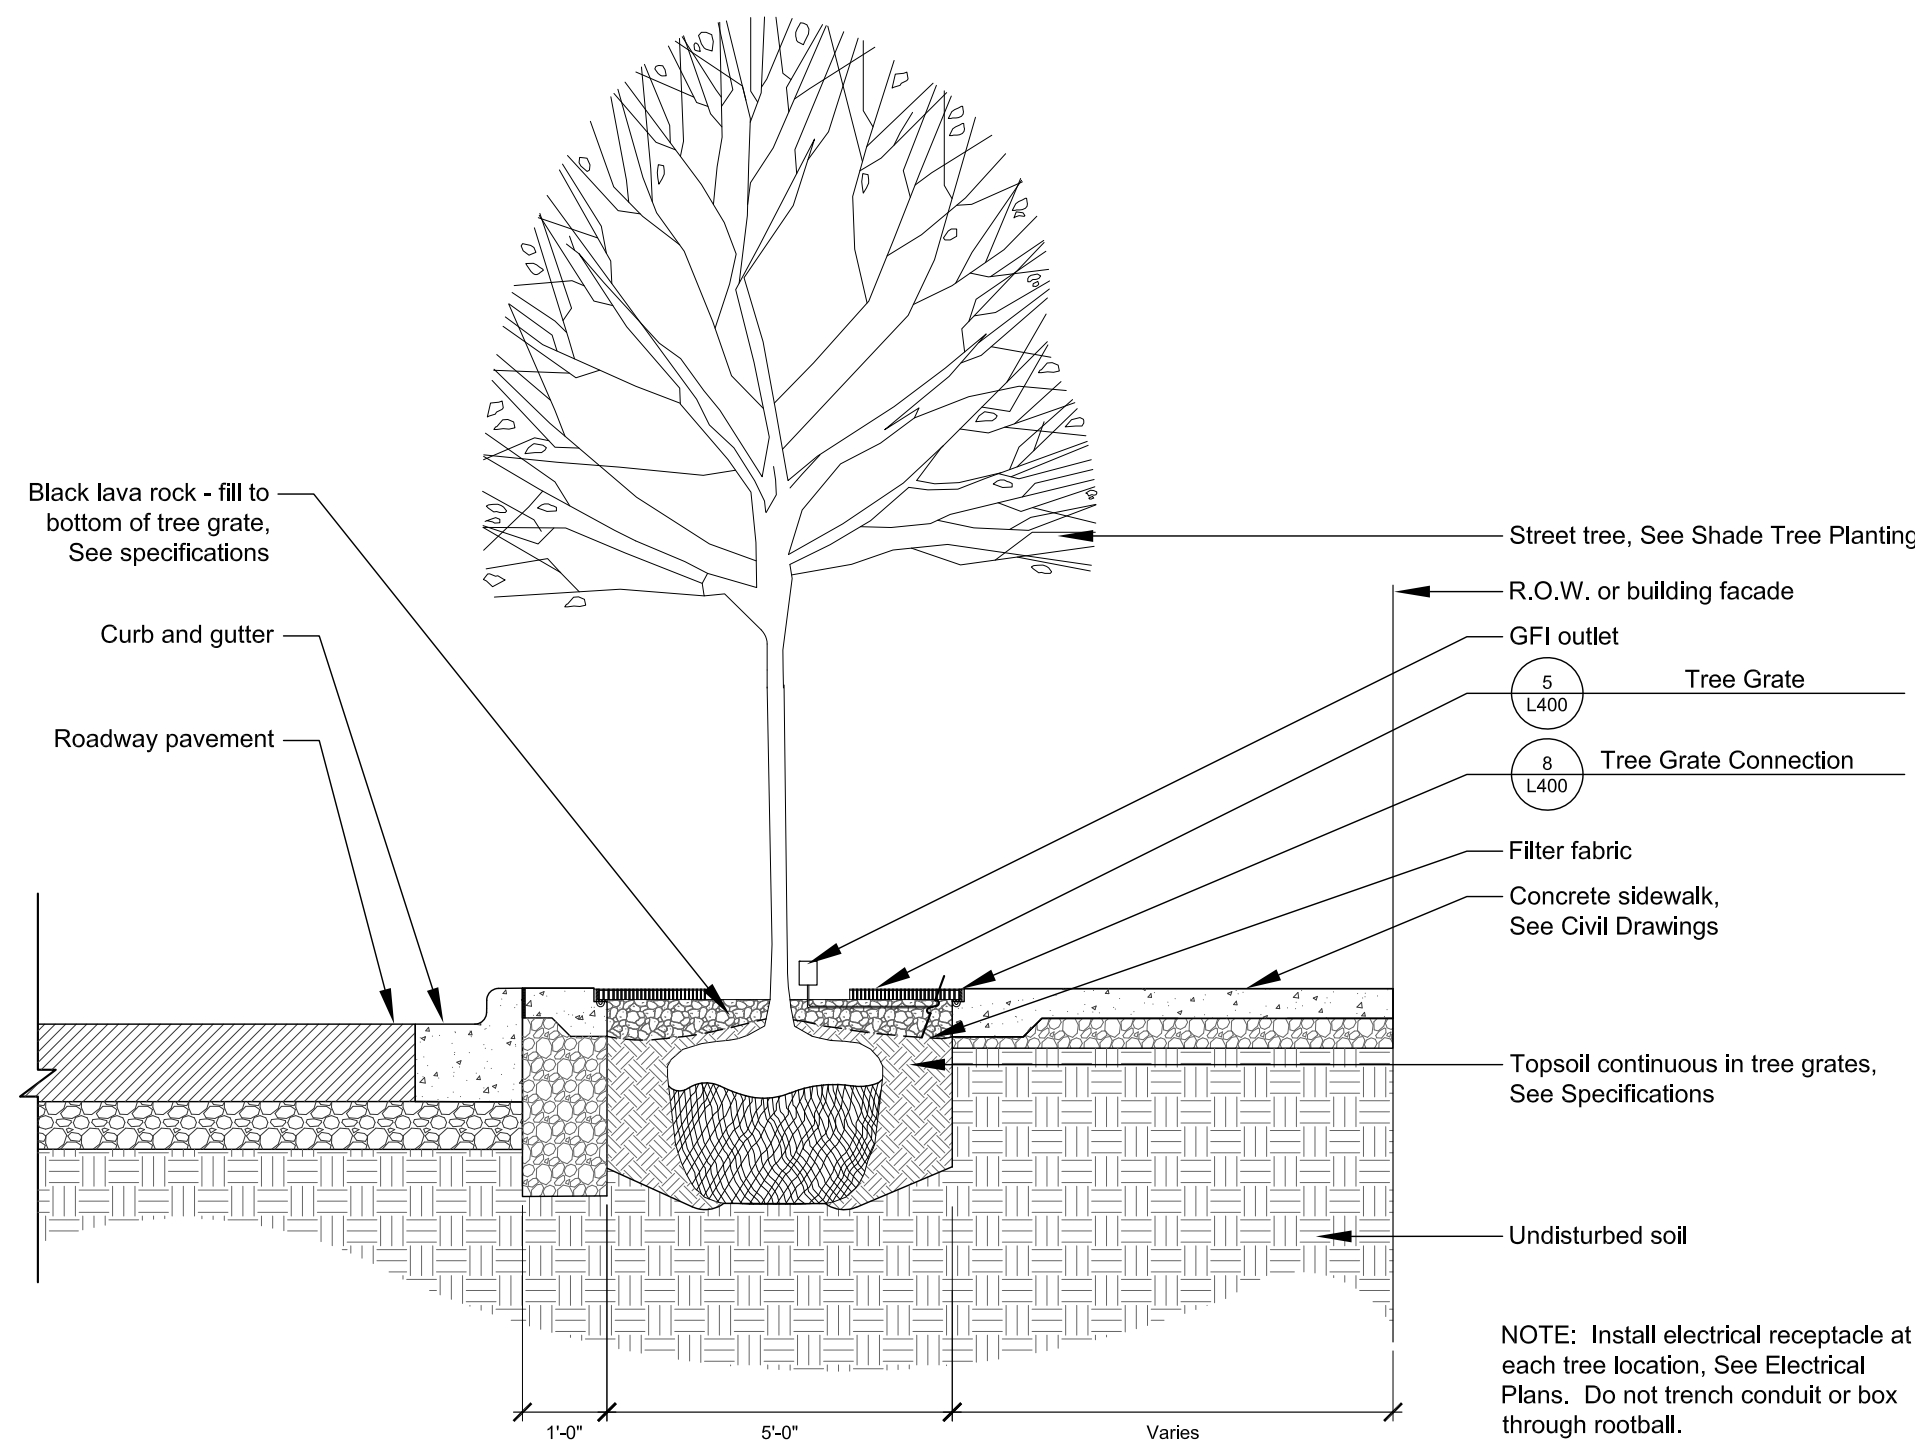

6 Section - Sidewalk Through Tree Grate







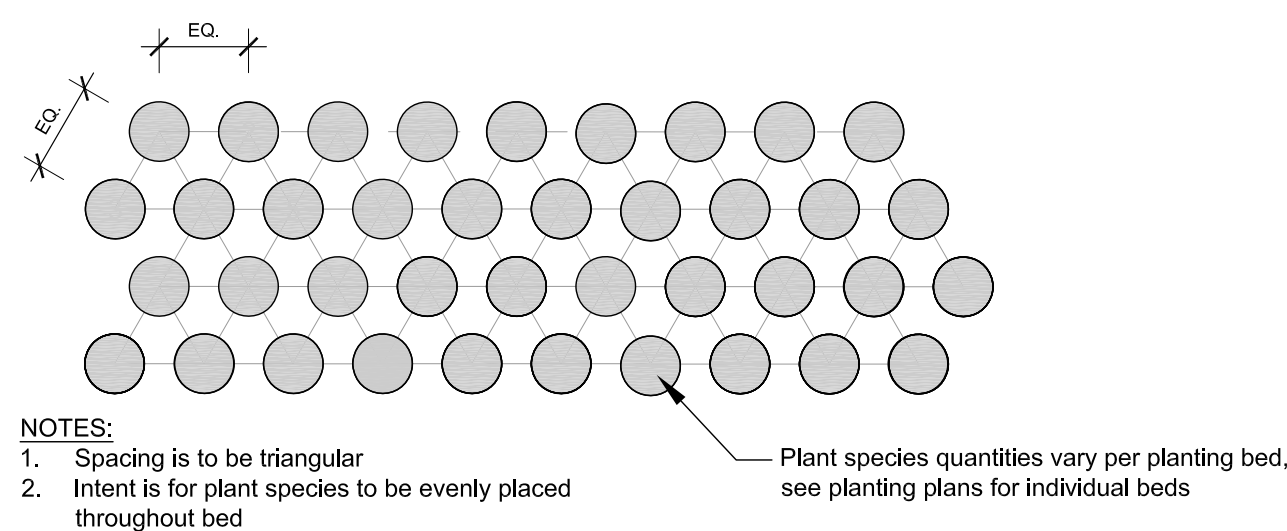


7 Perennial Spacing And Planting Pattern








# In Progress Details Included For Reference Only

## 1 Ornamental Fence

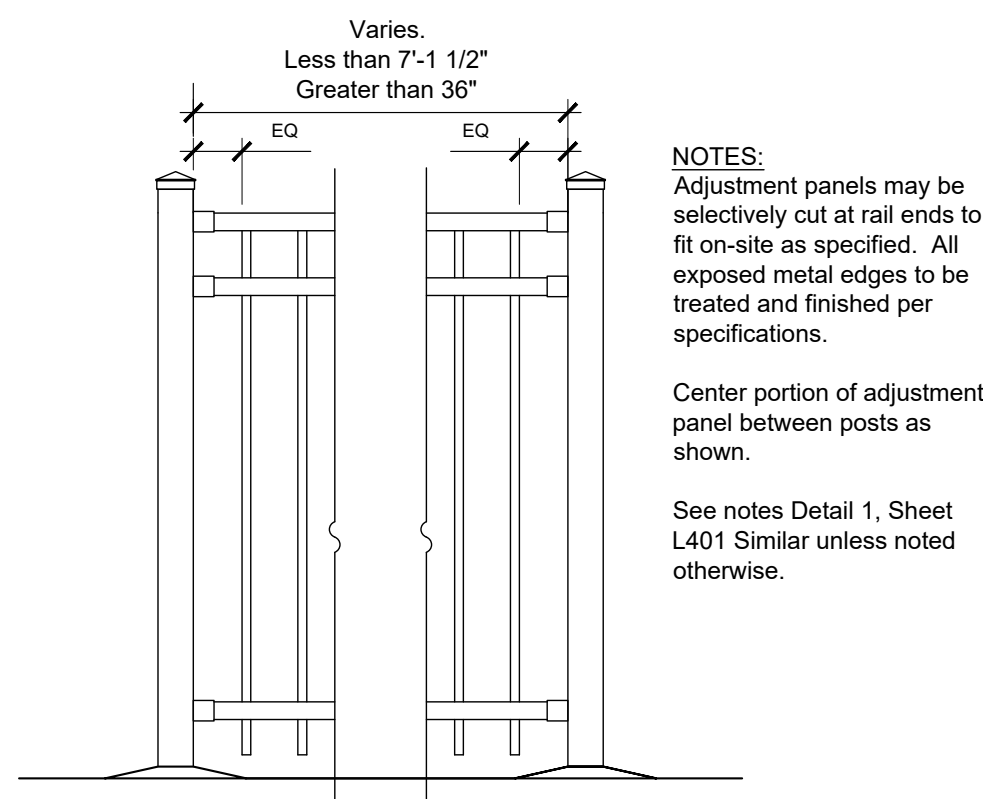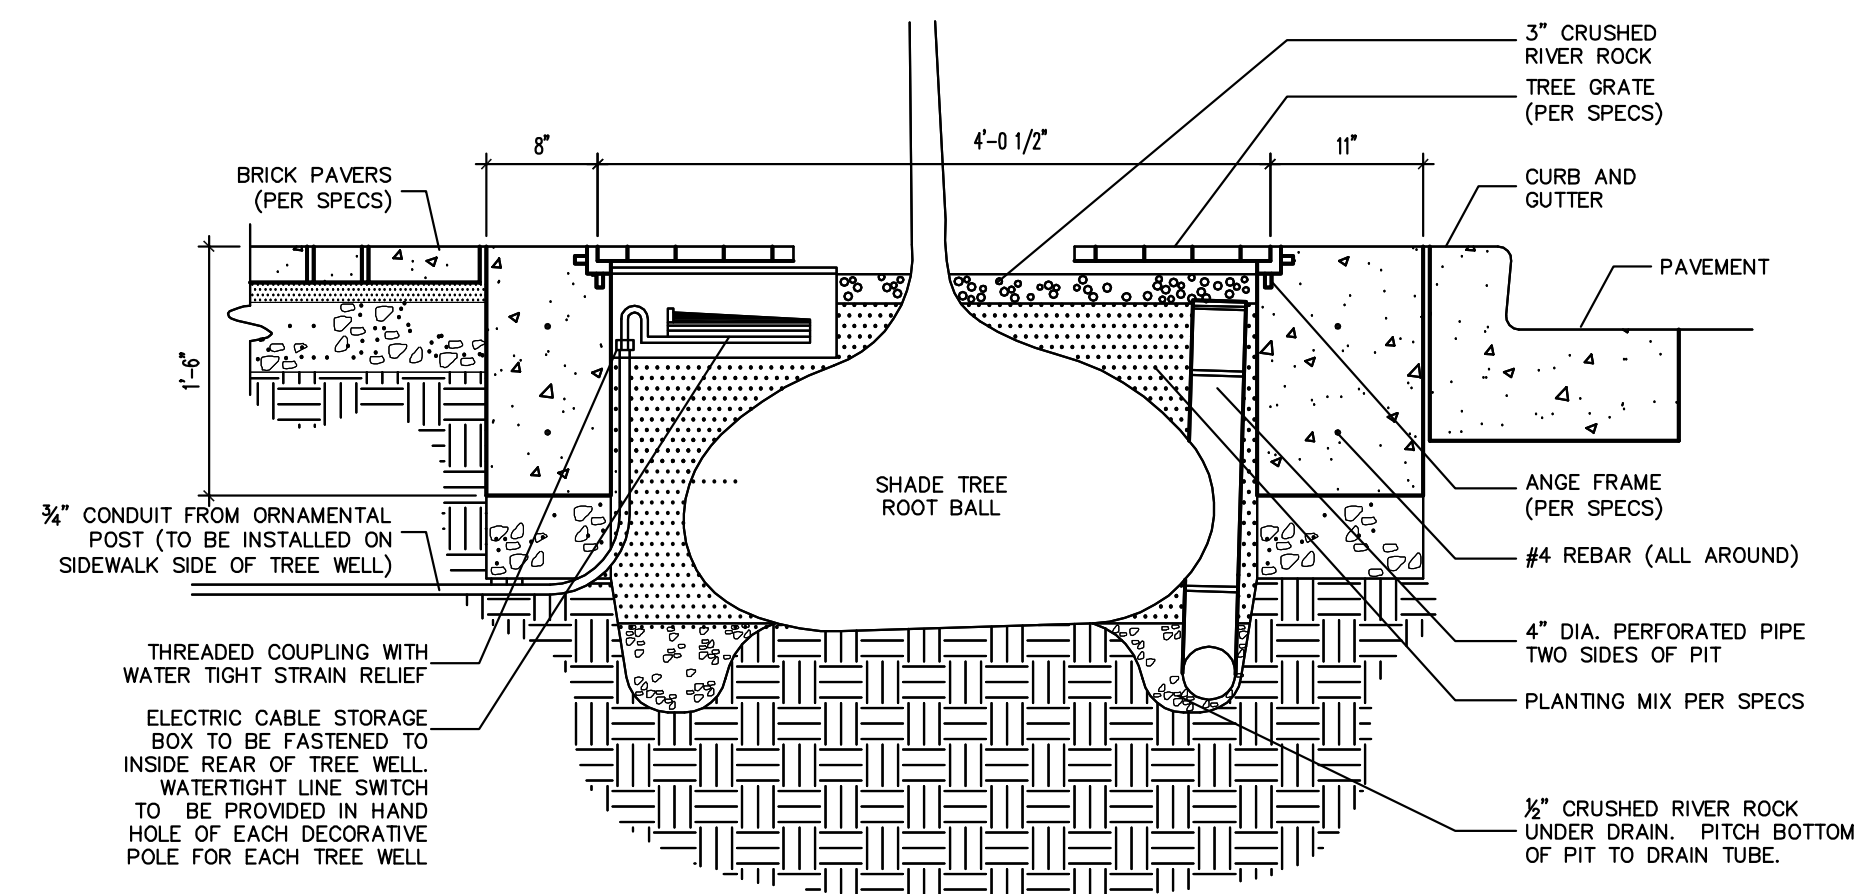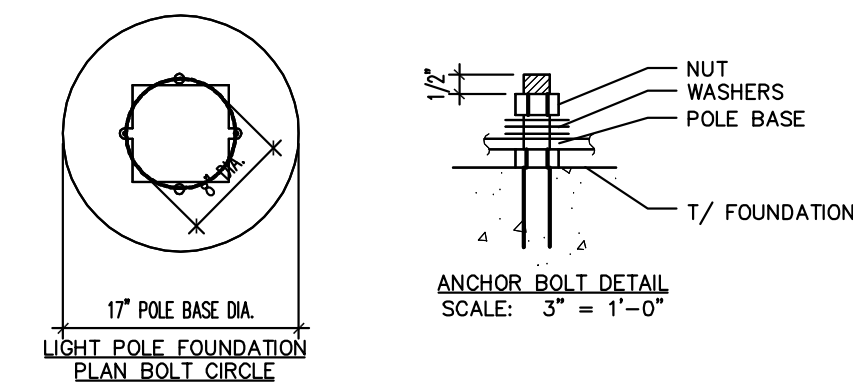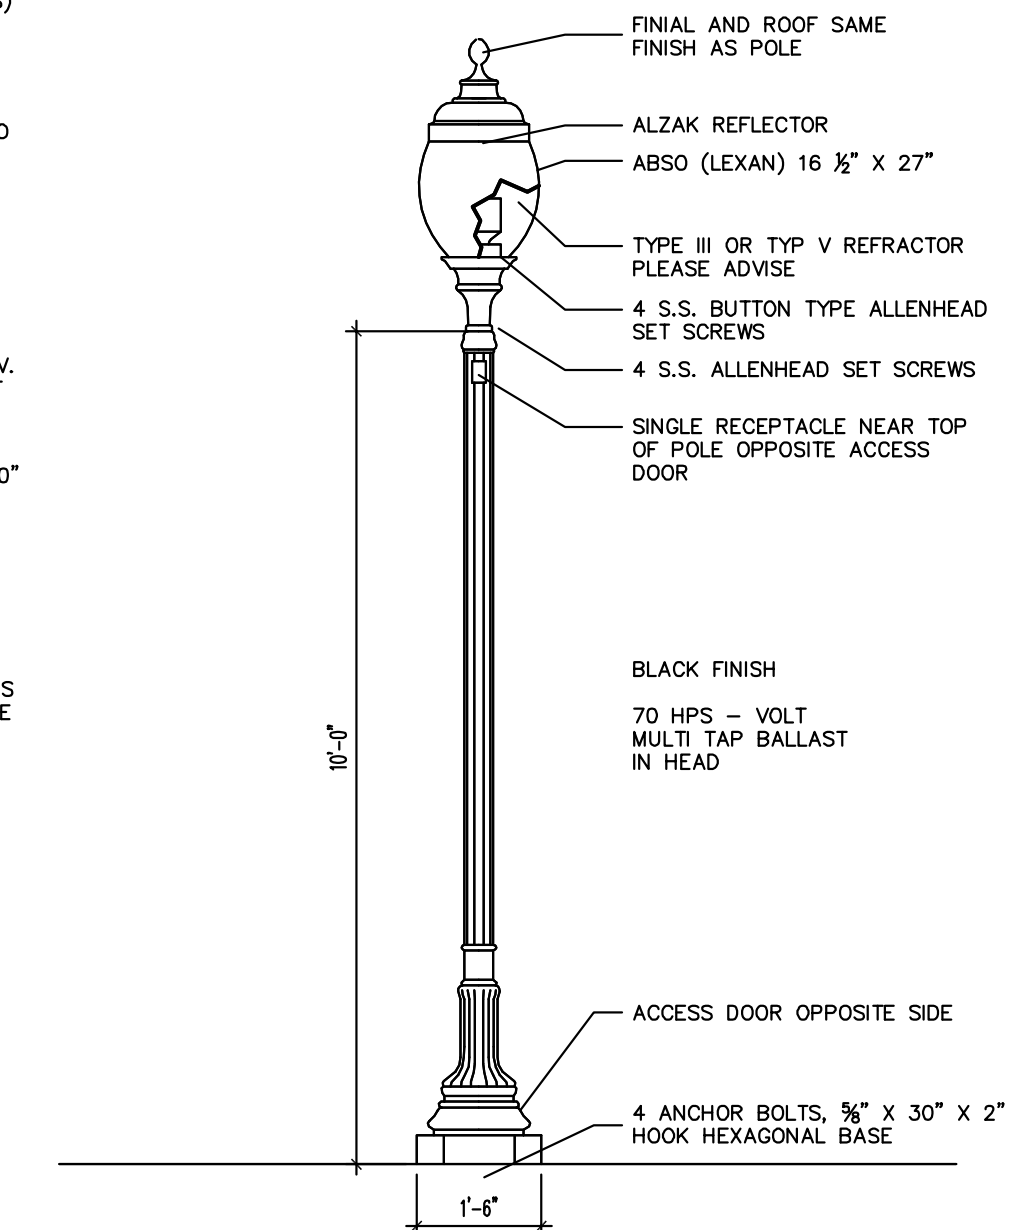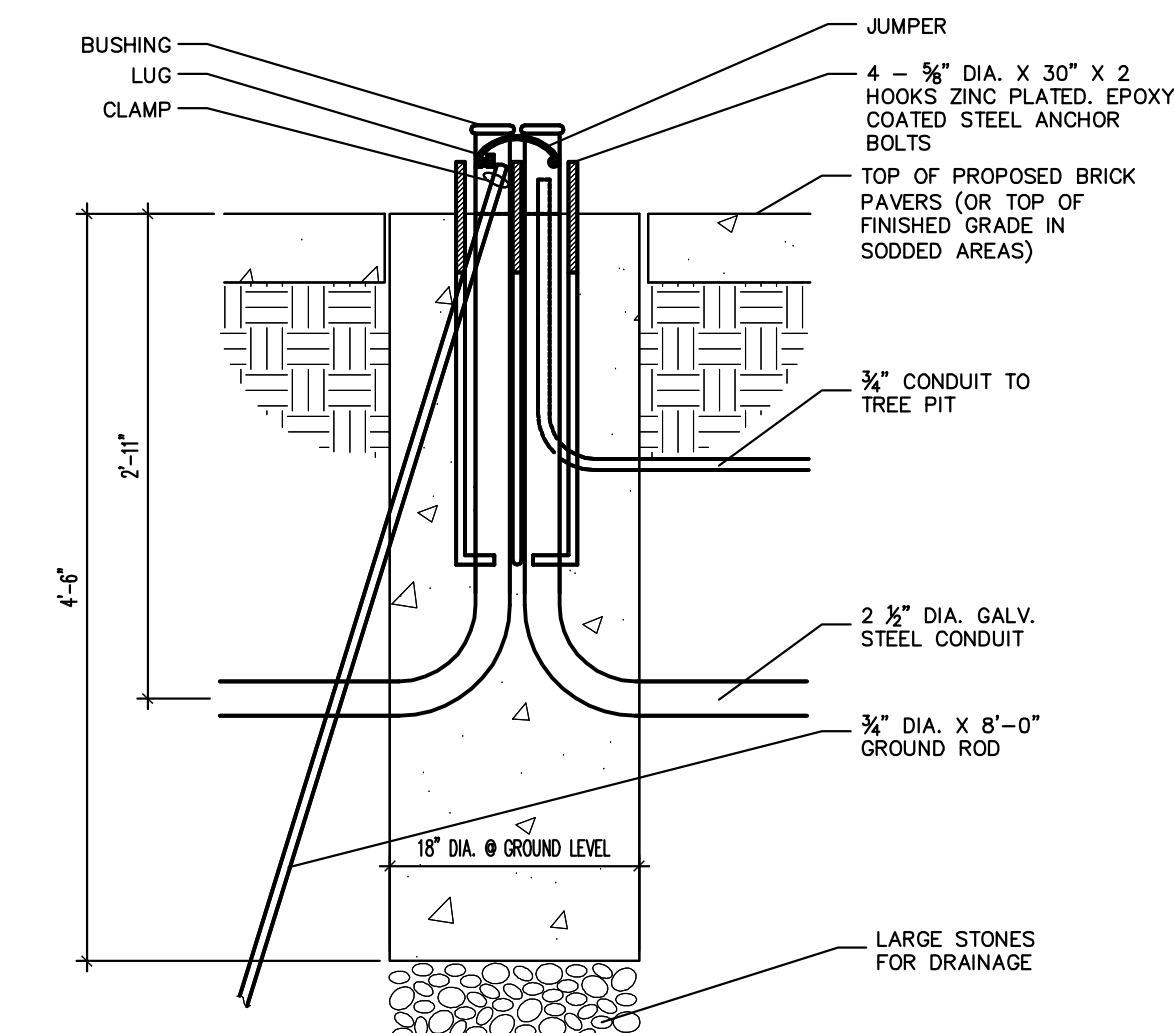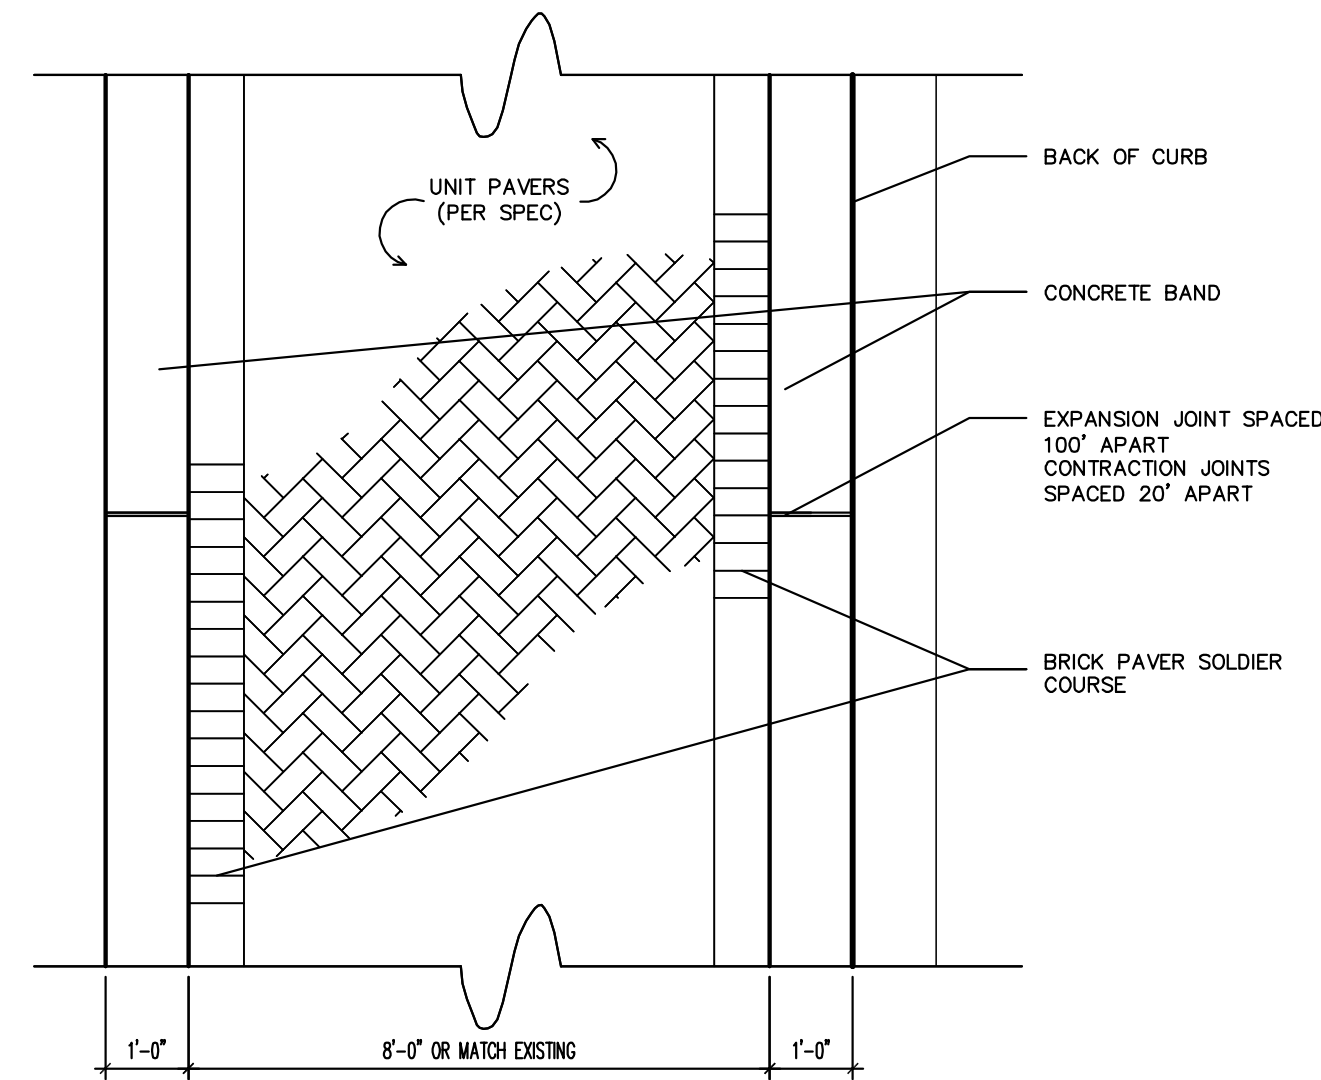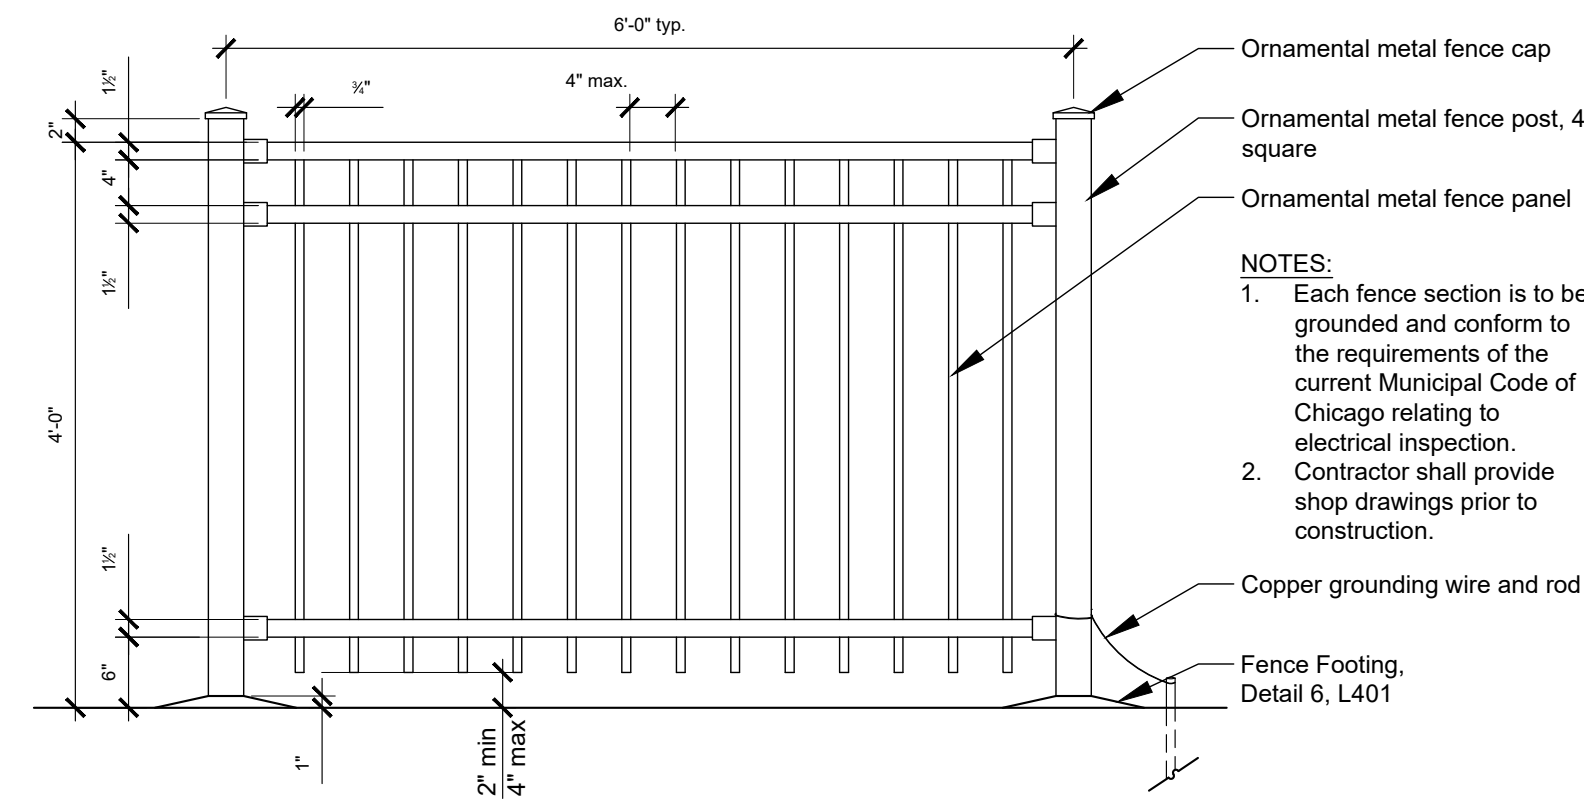


## 2 Ornamental Fence Adjustable Panel

 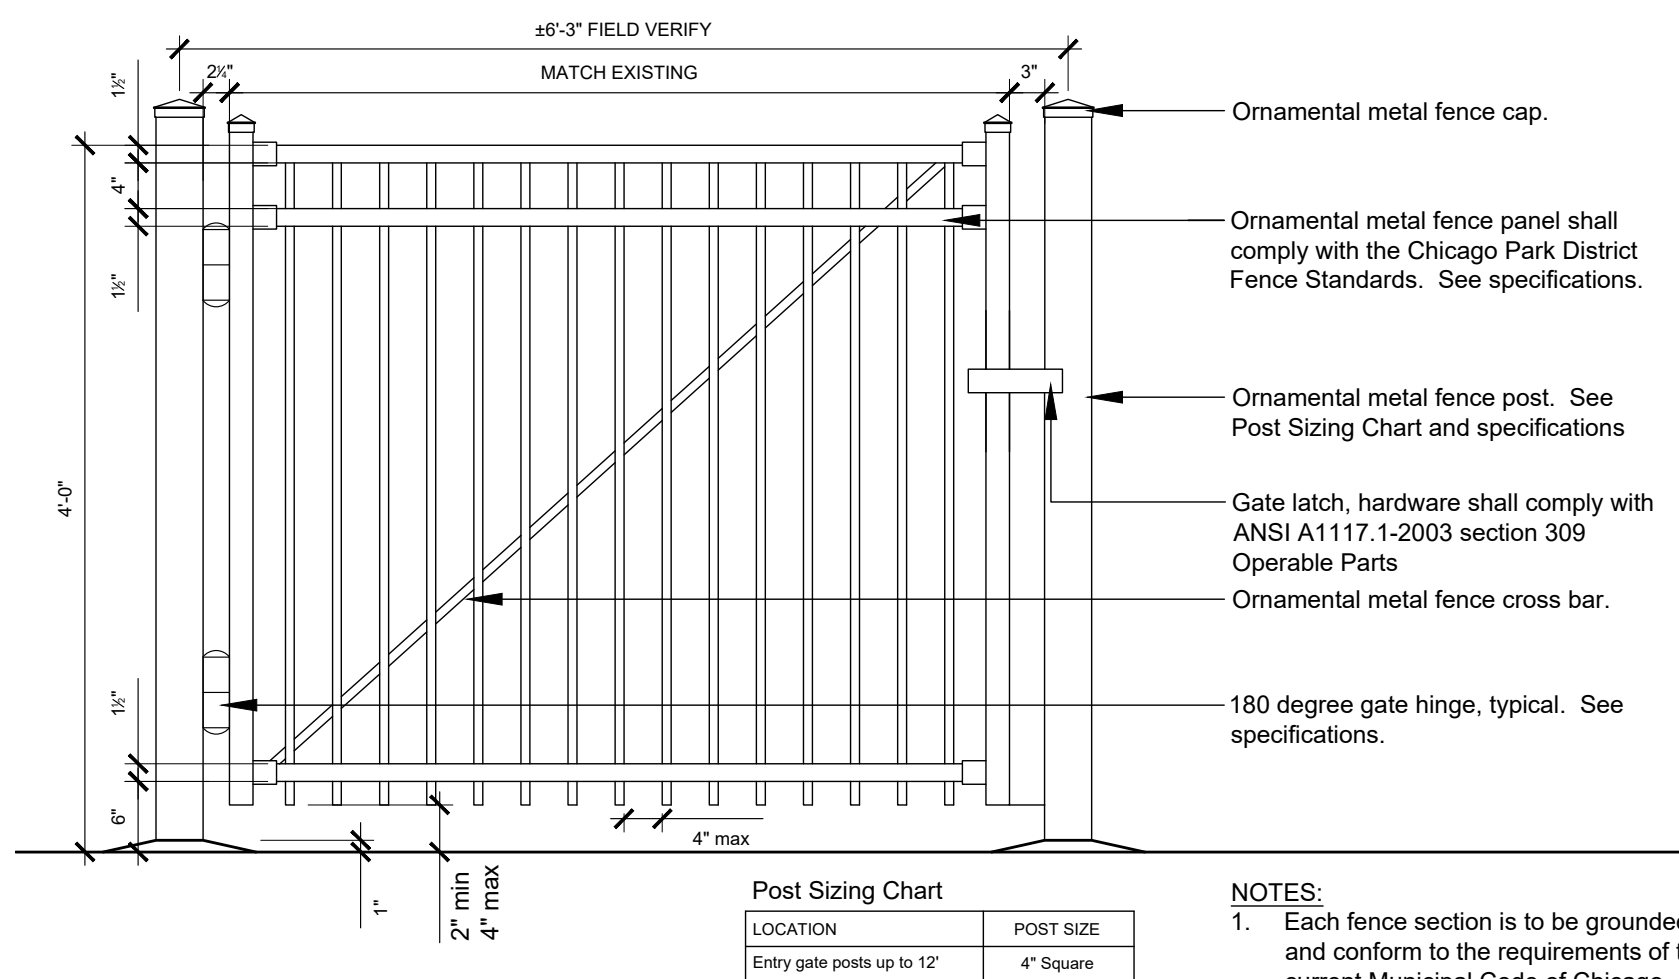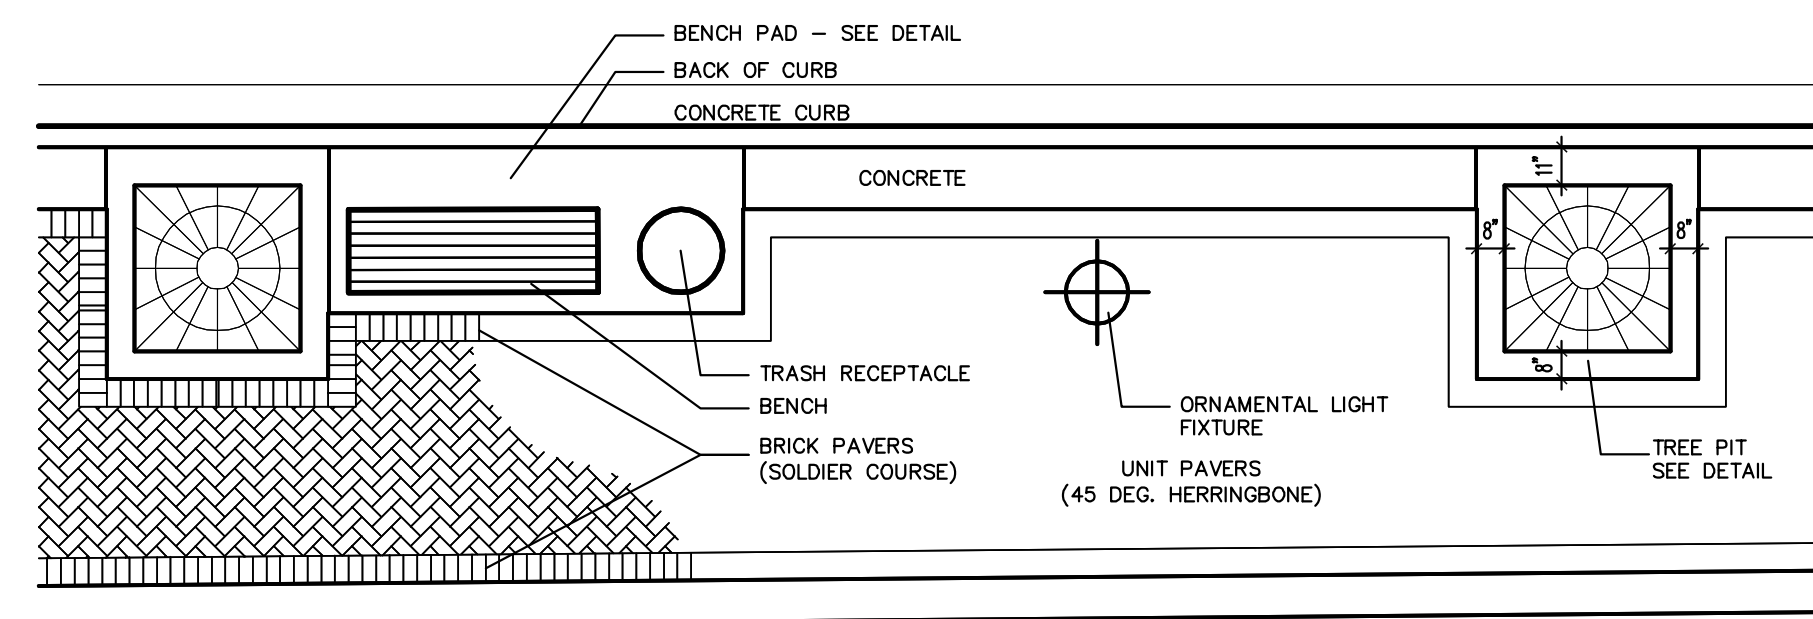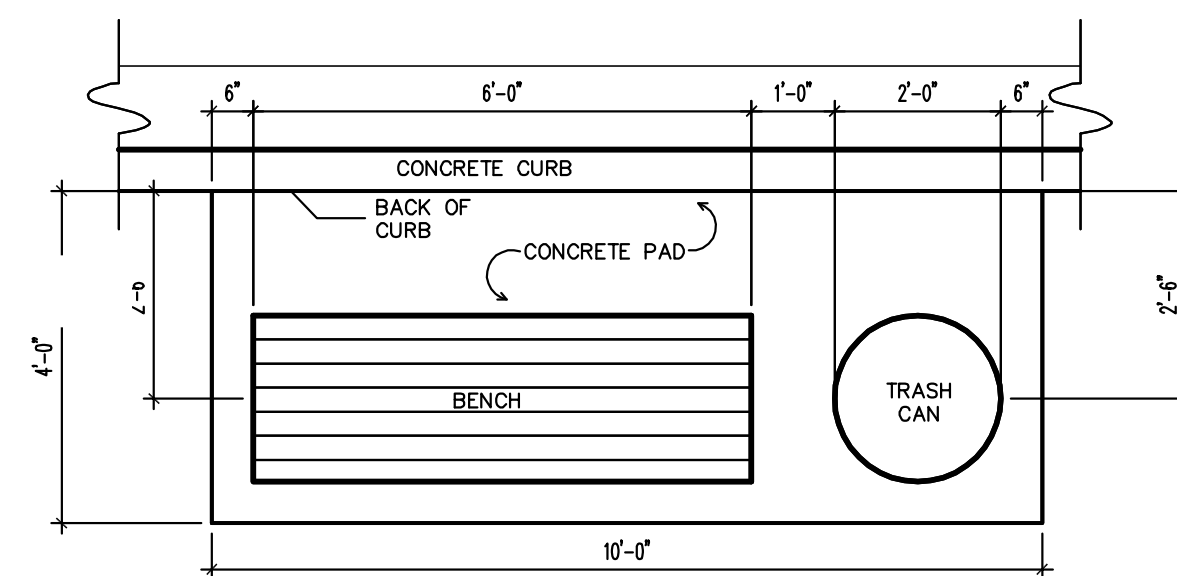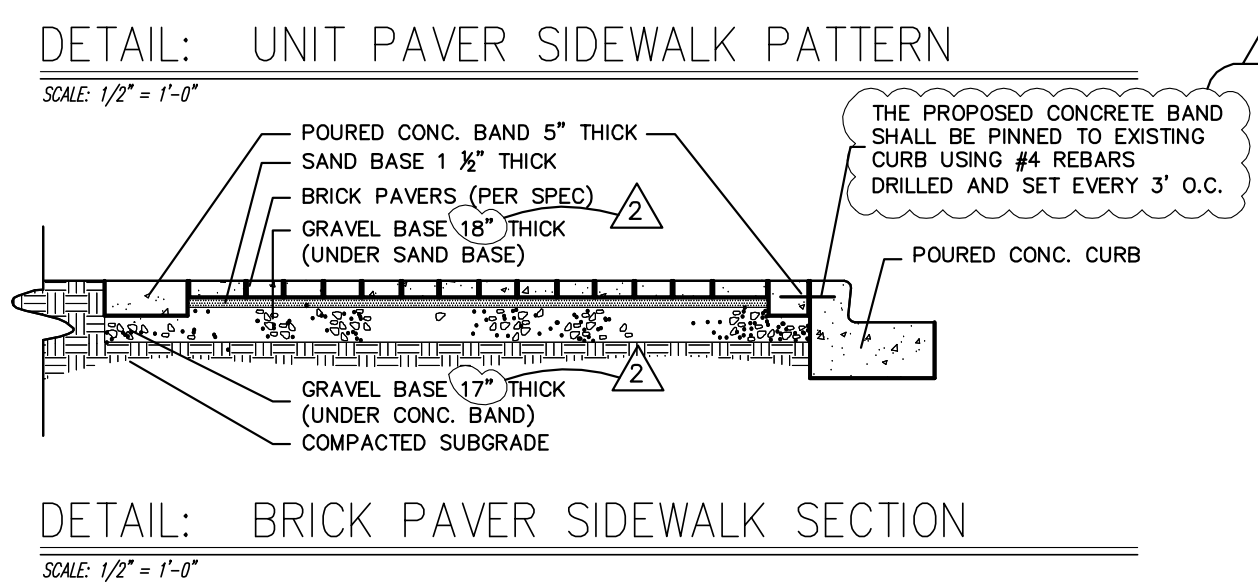


### 3 Ornamental Metal Gate



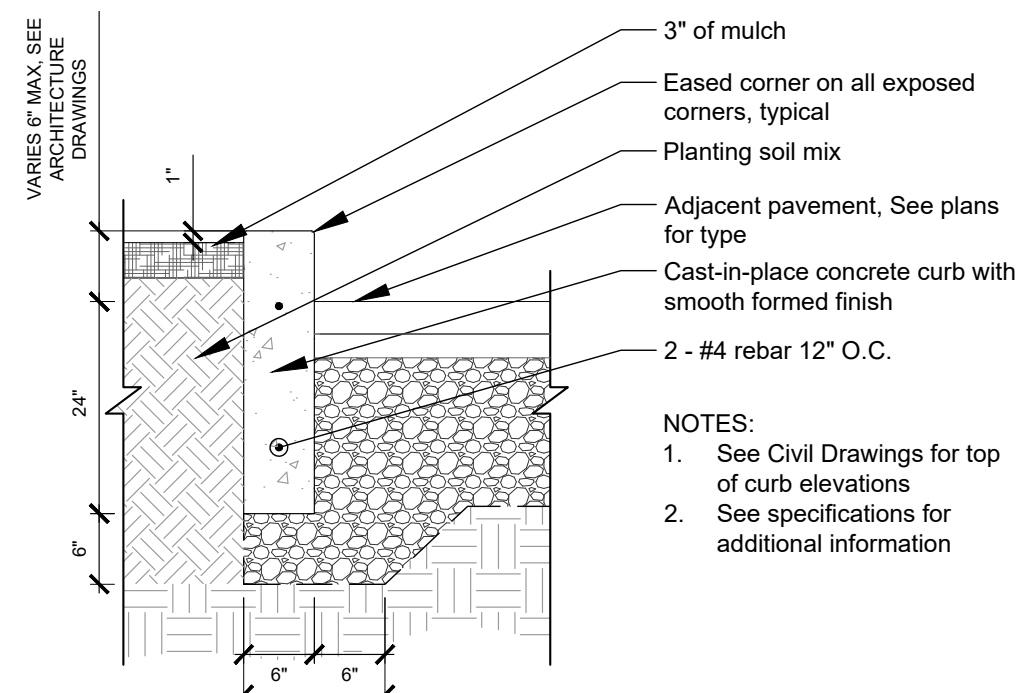


1 Concrete Planter Curb

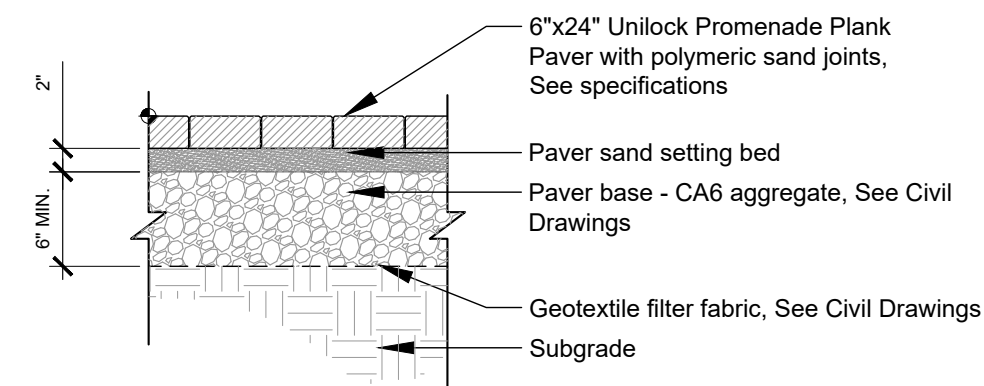


5 Unit Pavers


# In Progress Details Included For Reference Only

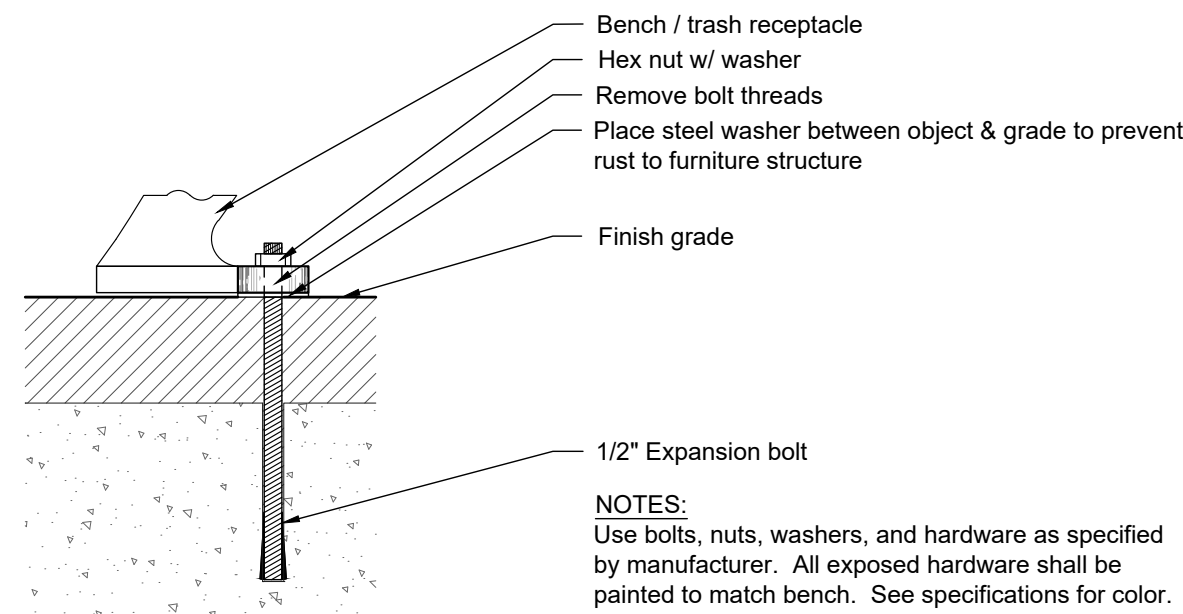


3 Bench Receptacle Attachment

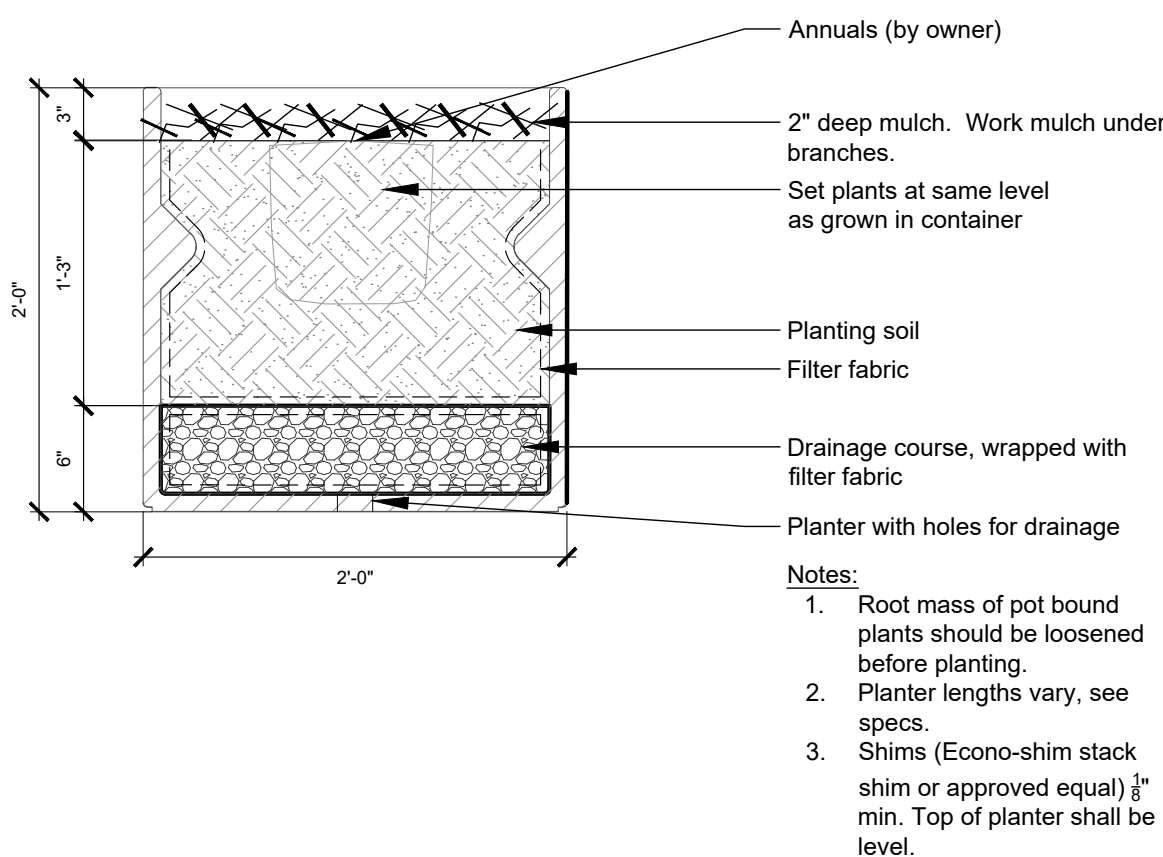

4 Planter GFRC

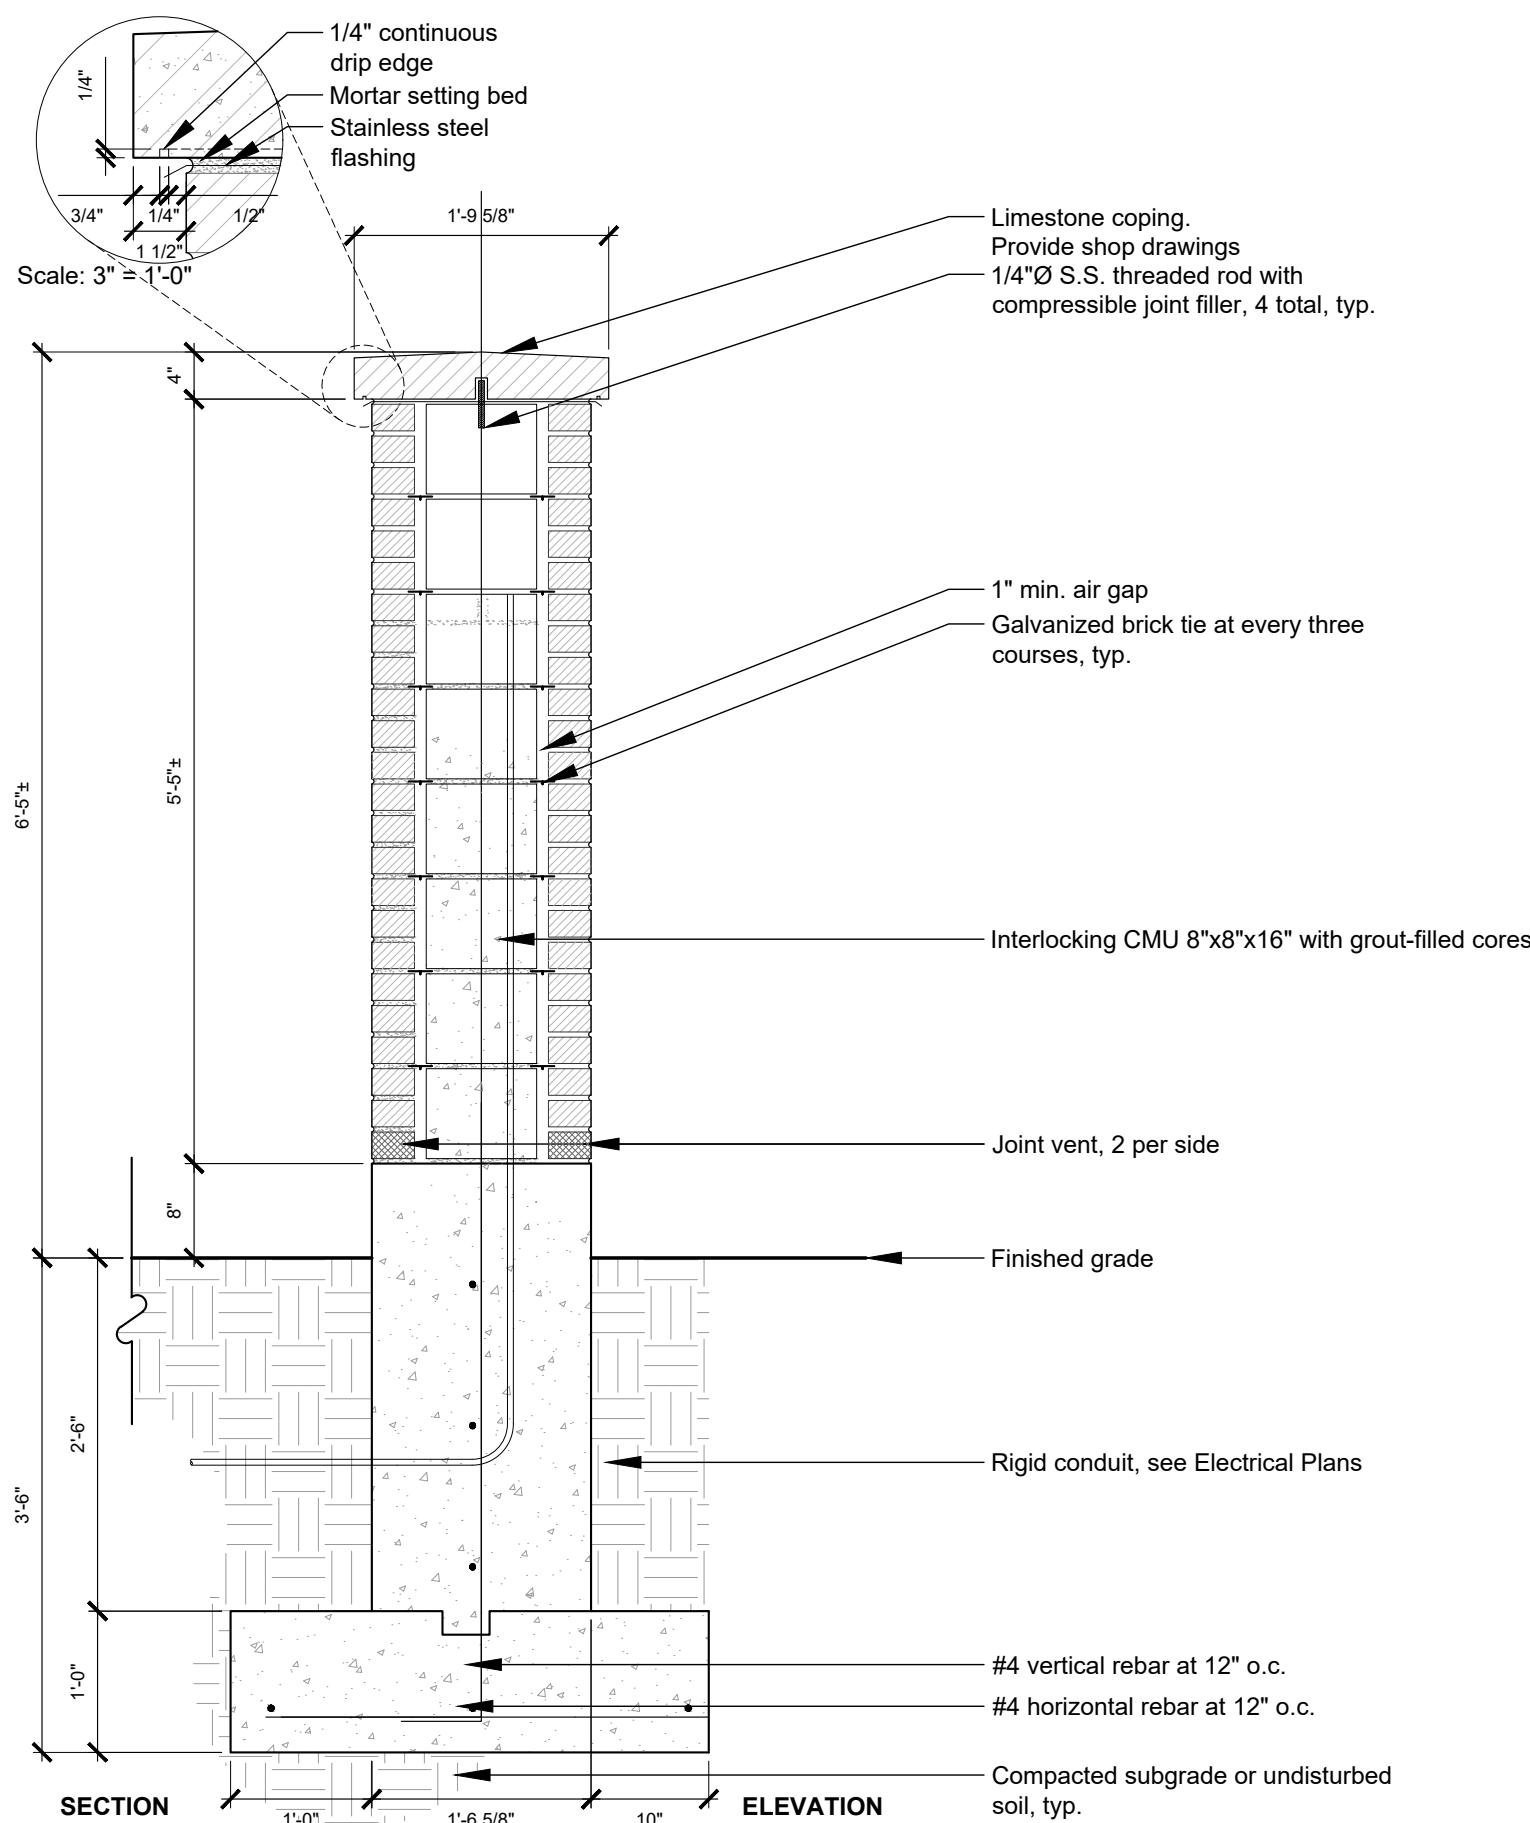


7 Brick Wall

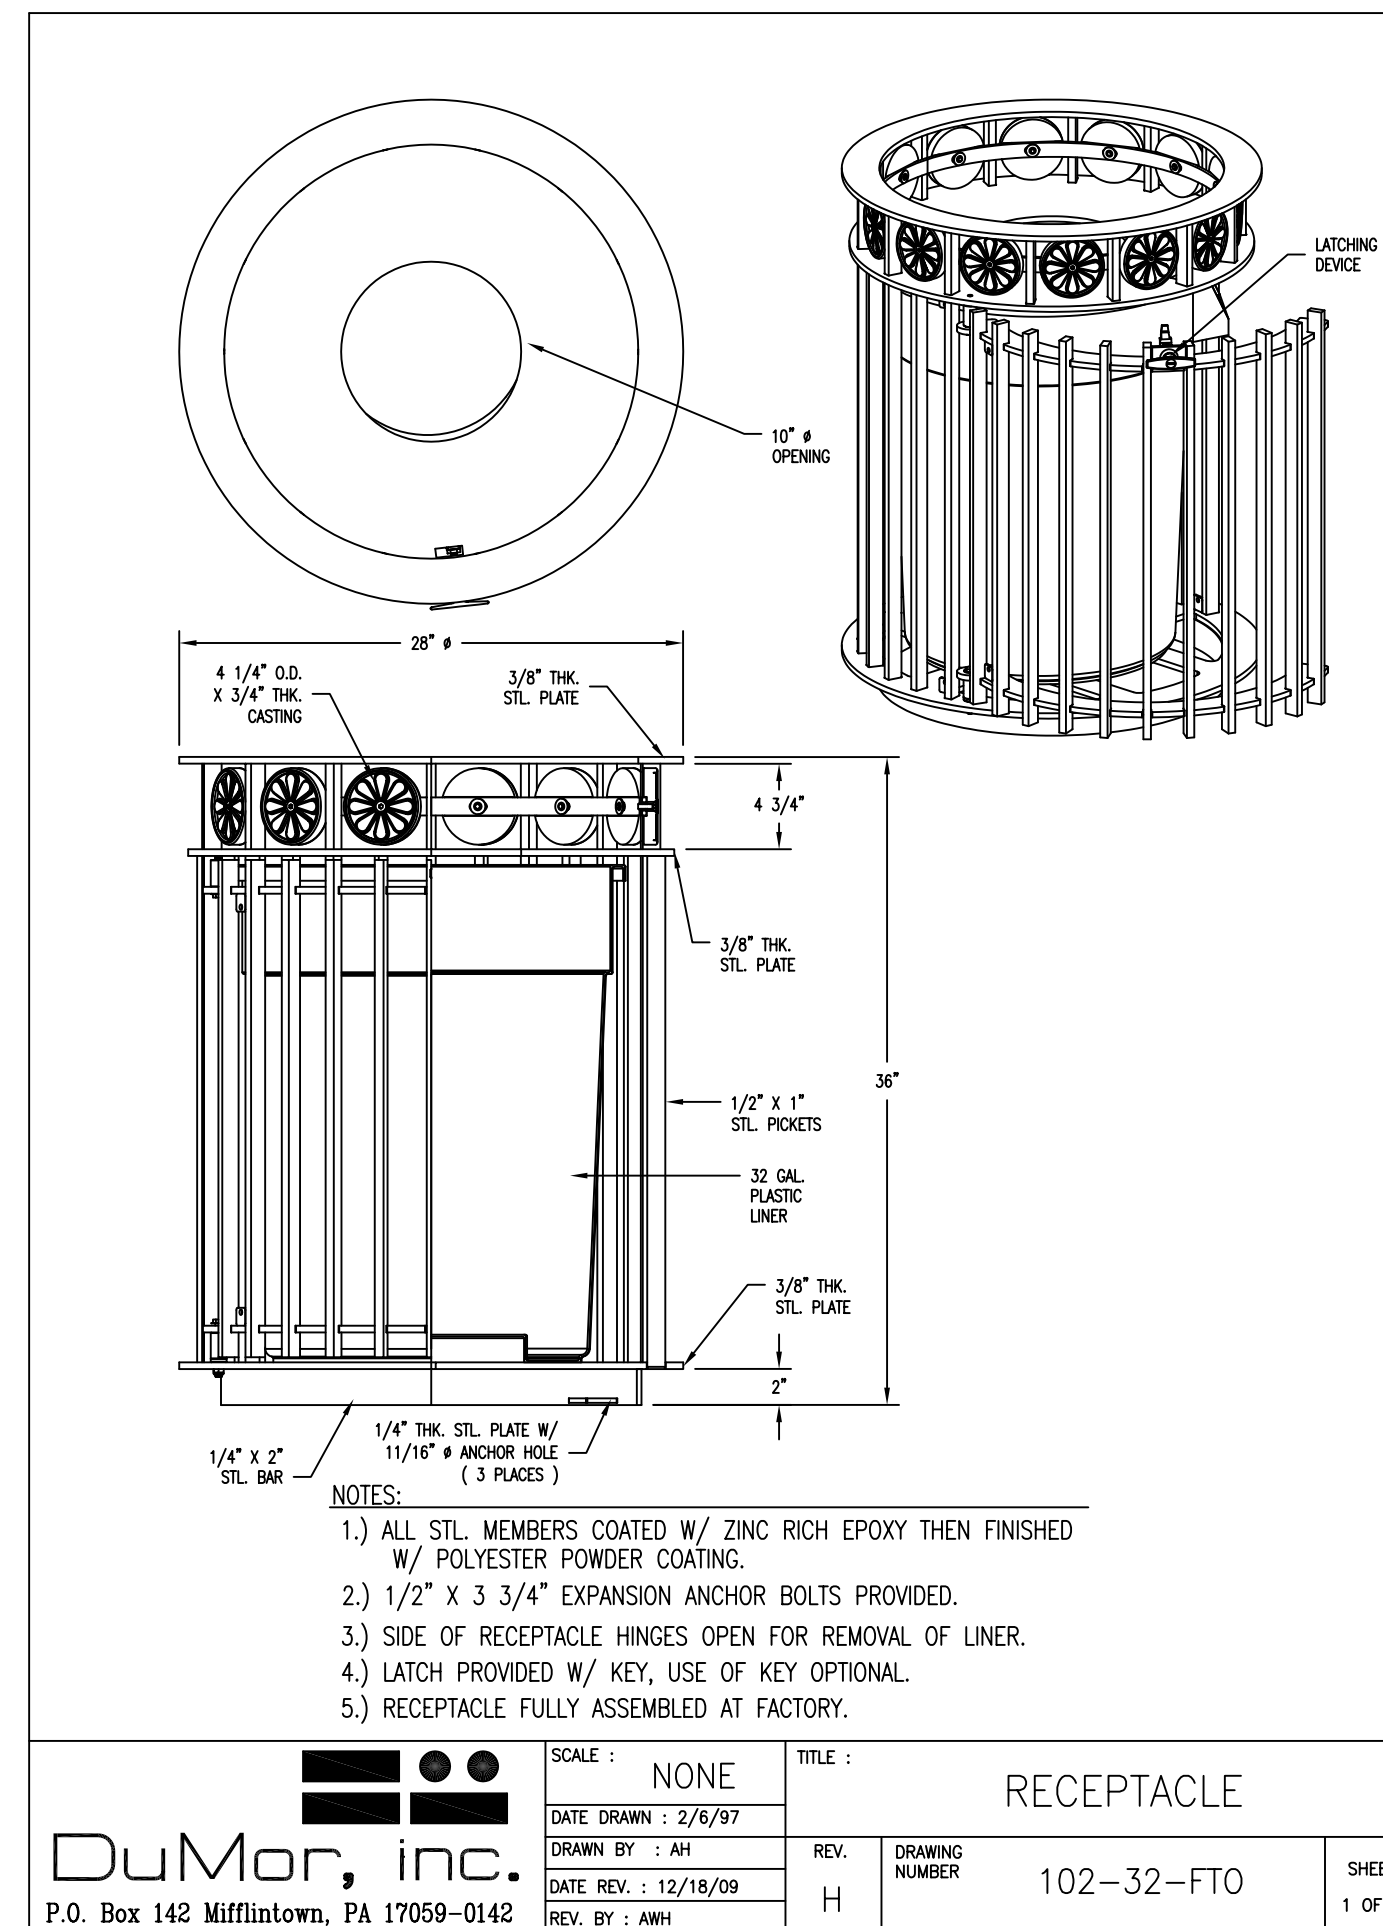

SCALE : NONE  
DATE DRAWN : 2/6/97  
DRAWN BY : AH  
DATE REV. : 12/18/09  
REV. BY : AMH

TITLE : RECEPTACLE


REV. H  
DRAWING NUMBER 102-32-FTO  
SHEET 1 OF 2

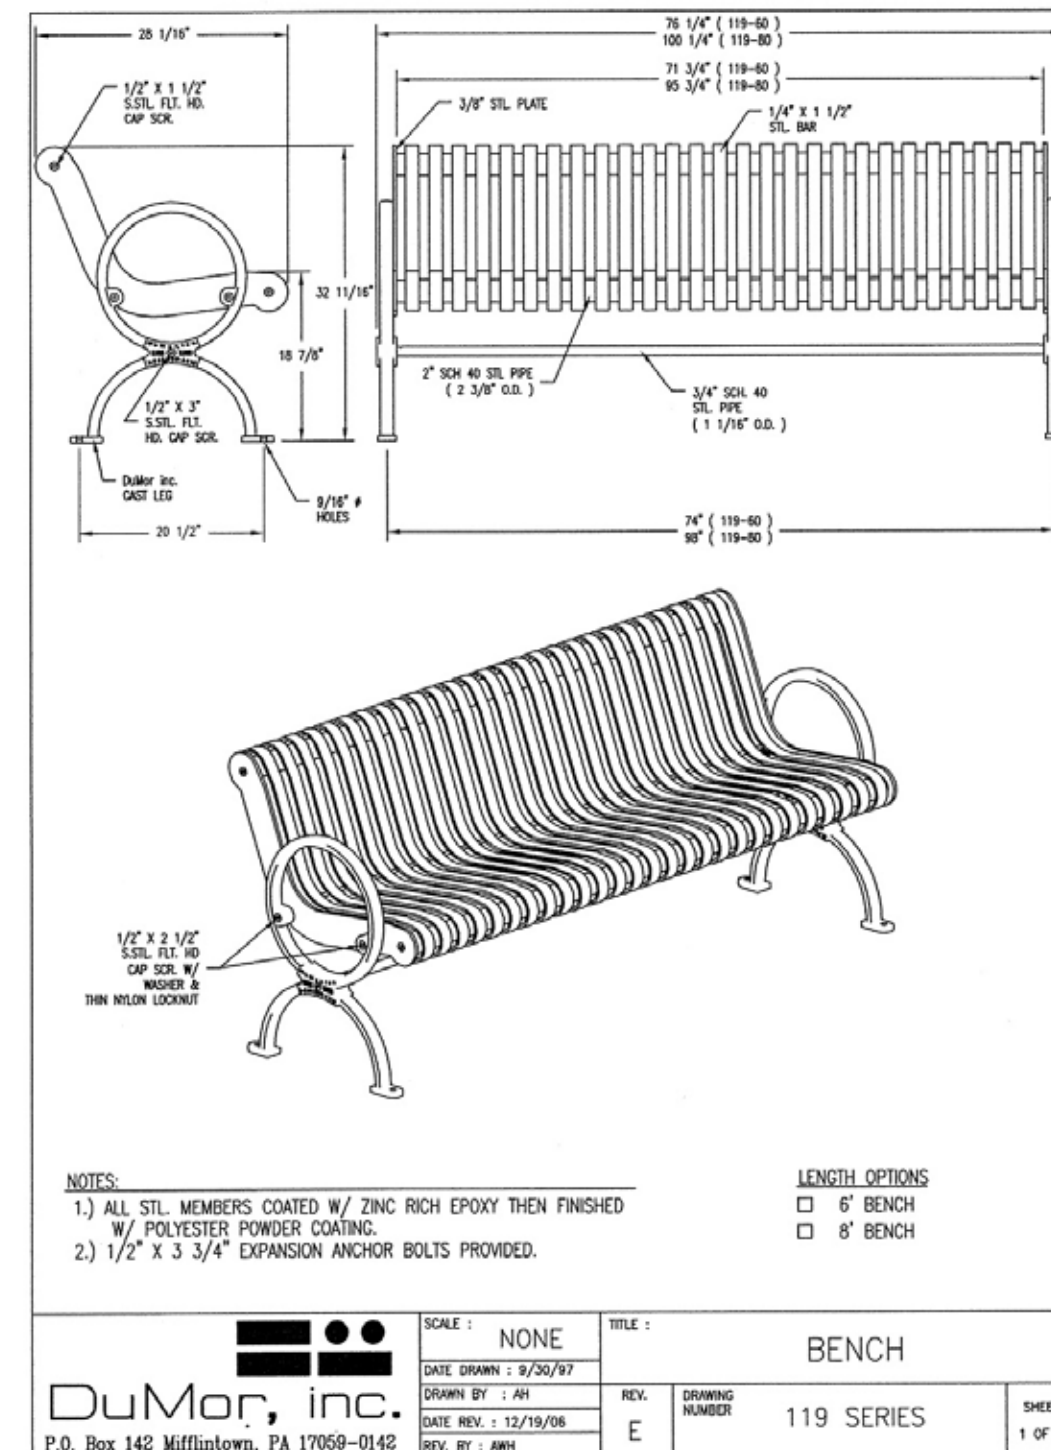

SCALE : NONE  
DATE DRAWN : 9/20/97  
DRAWN BY : JH  
DATE REV. : 12/18/09  
REV. BY : AMH

TITLE : BENCH

REV. E  
DRAWING NUMBER 119 SERIES  
SHEET 1 OF 2

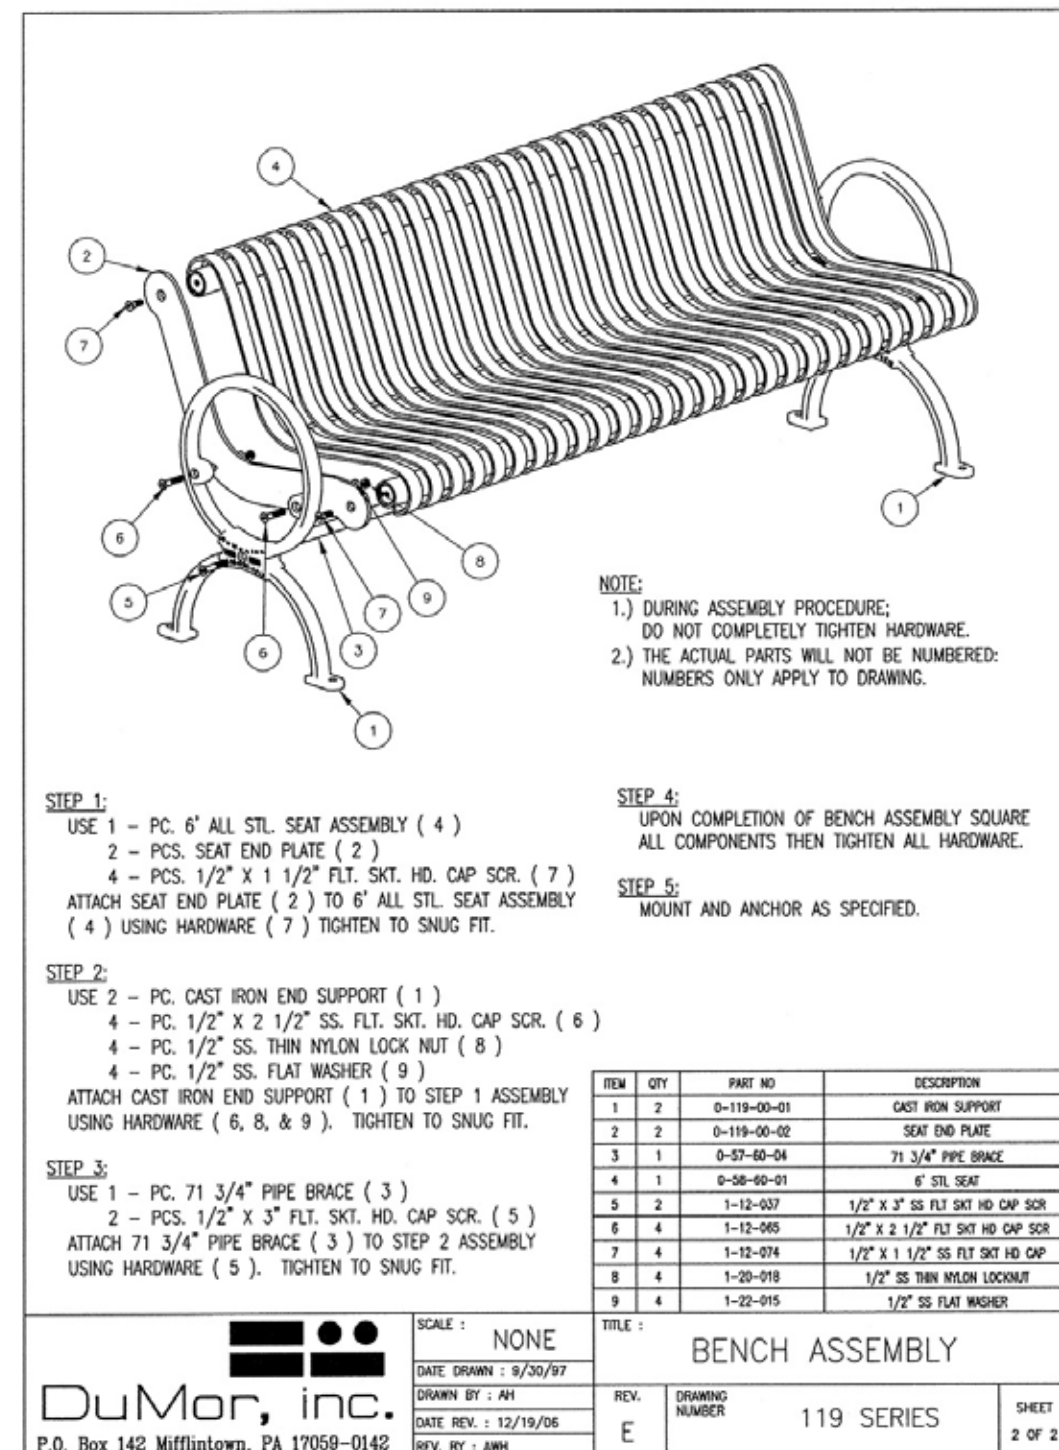


SCALE : NONE  
DATE DRAWN : 9/20/97  
DRAWN BY : JH  
DATE REV. : 12/18/09  
REV. BY : AMH

TITLE : BENCH ASSEMBLY

REV. E  
DRAWING NUMBER 119 SERIES  
SHEET 2 OF 2


(A) ORDER:  
CENTER  
ARM  
REST  
(B) ANCHOR  
BENCH w/  
STAINLESS  
STEEL  
BOLTS  
**BENCH**  
(Not to Scale)

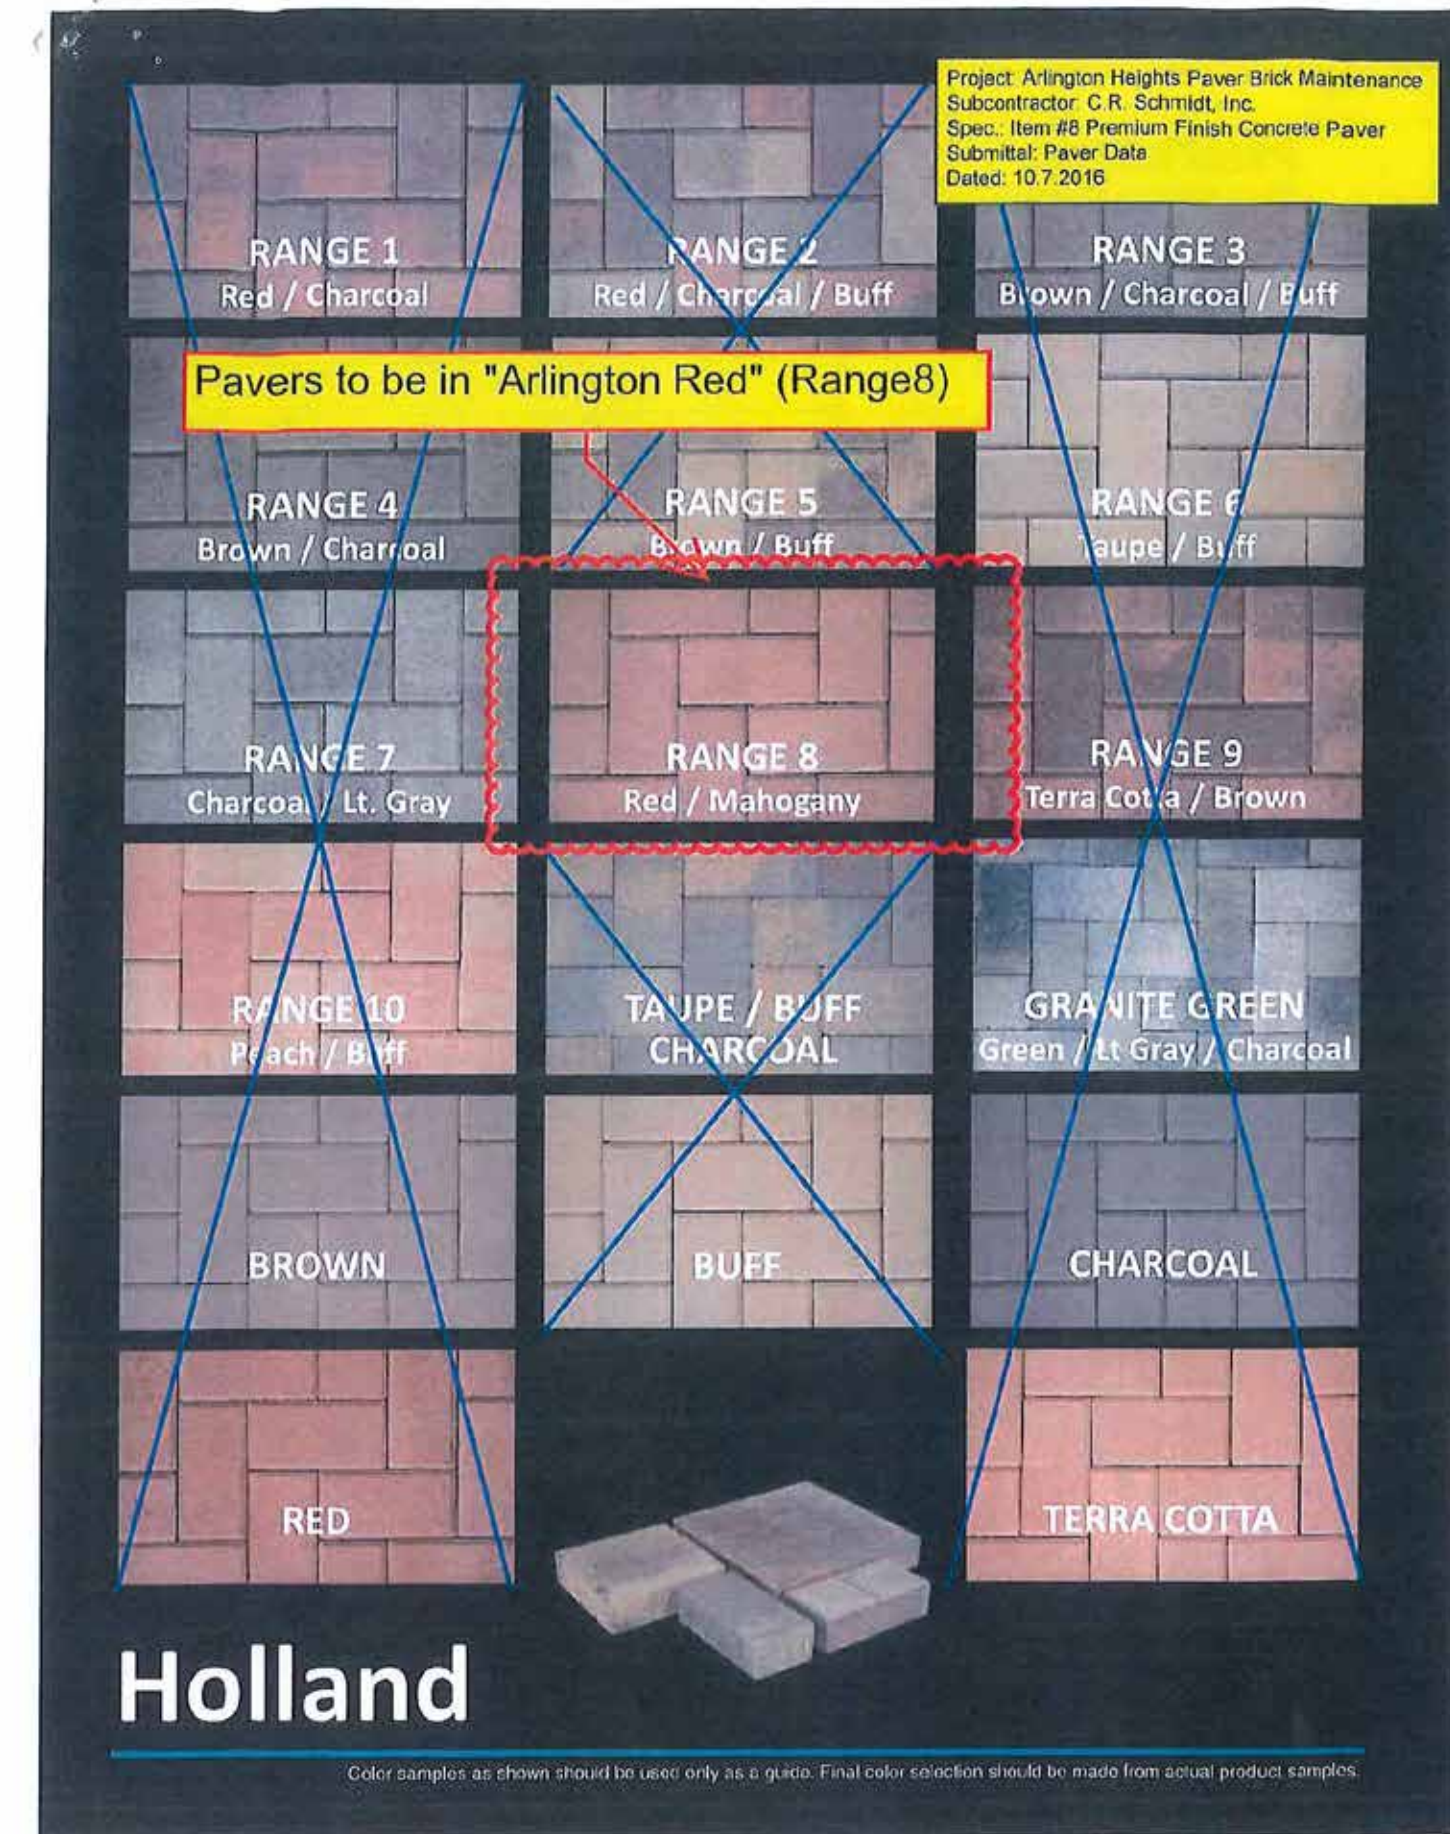





Existing Street Lighting

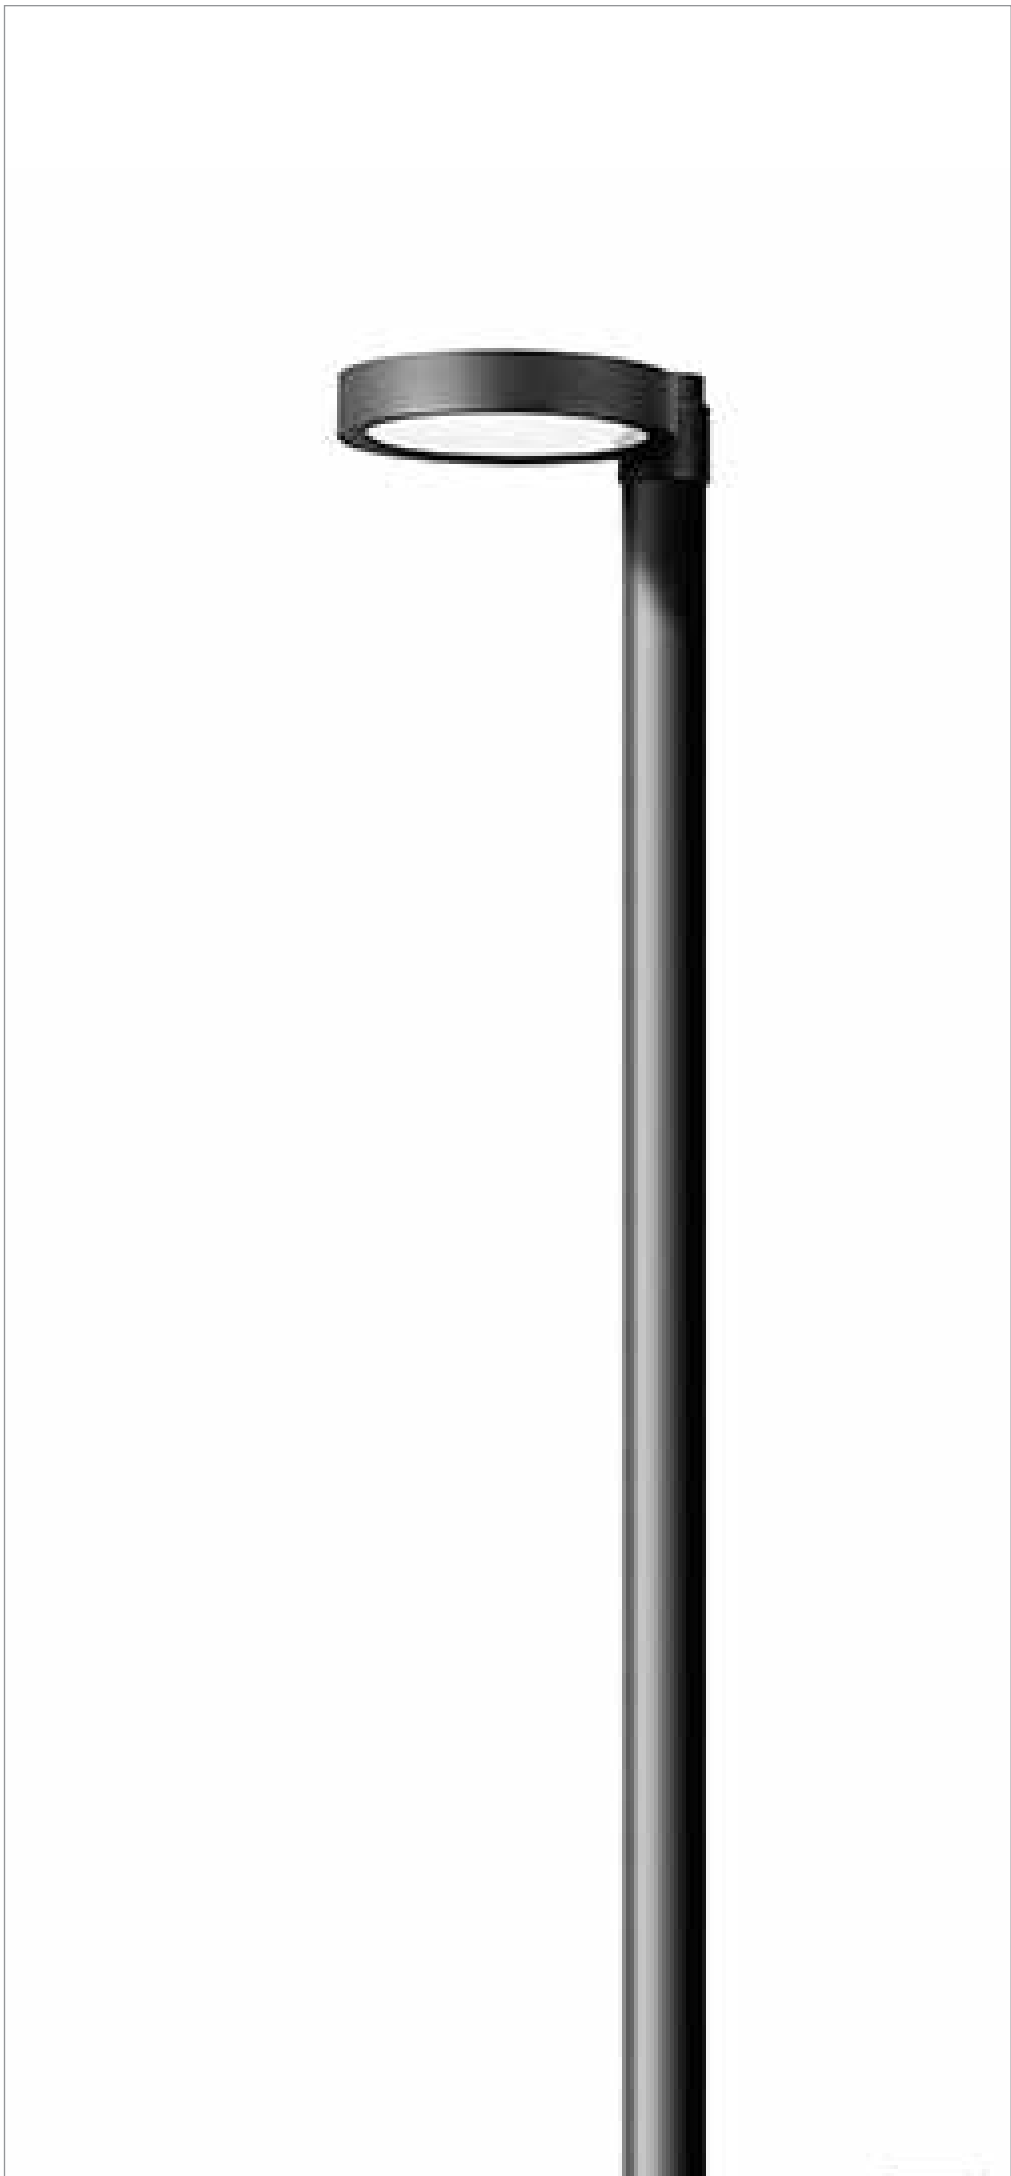

Ornamental Lighting



Bollard Lighting



Bollard Lighting



Wall Wash Lighting / Tree Uplighting



Wall Wash Lighting / Tree Uplighting



Niche Lighting



Courtyard Lighting



Wall Pack



Niche Lighting



# Lighting Options

## Arlington 425

Arlington Heights, Illinois

PREPARED FOR:  
CCH LLC

ISSUE DATE: February 18, 2019  
All drawings are preliminary and subject to change.  
© 2019 Hitchcock Design Group