


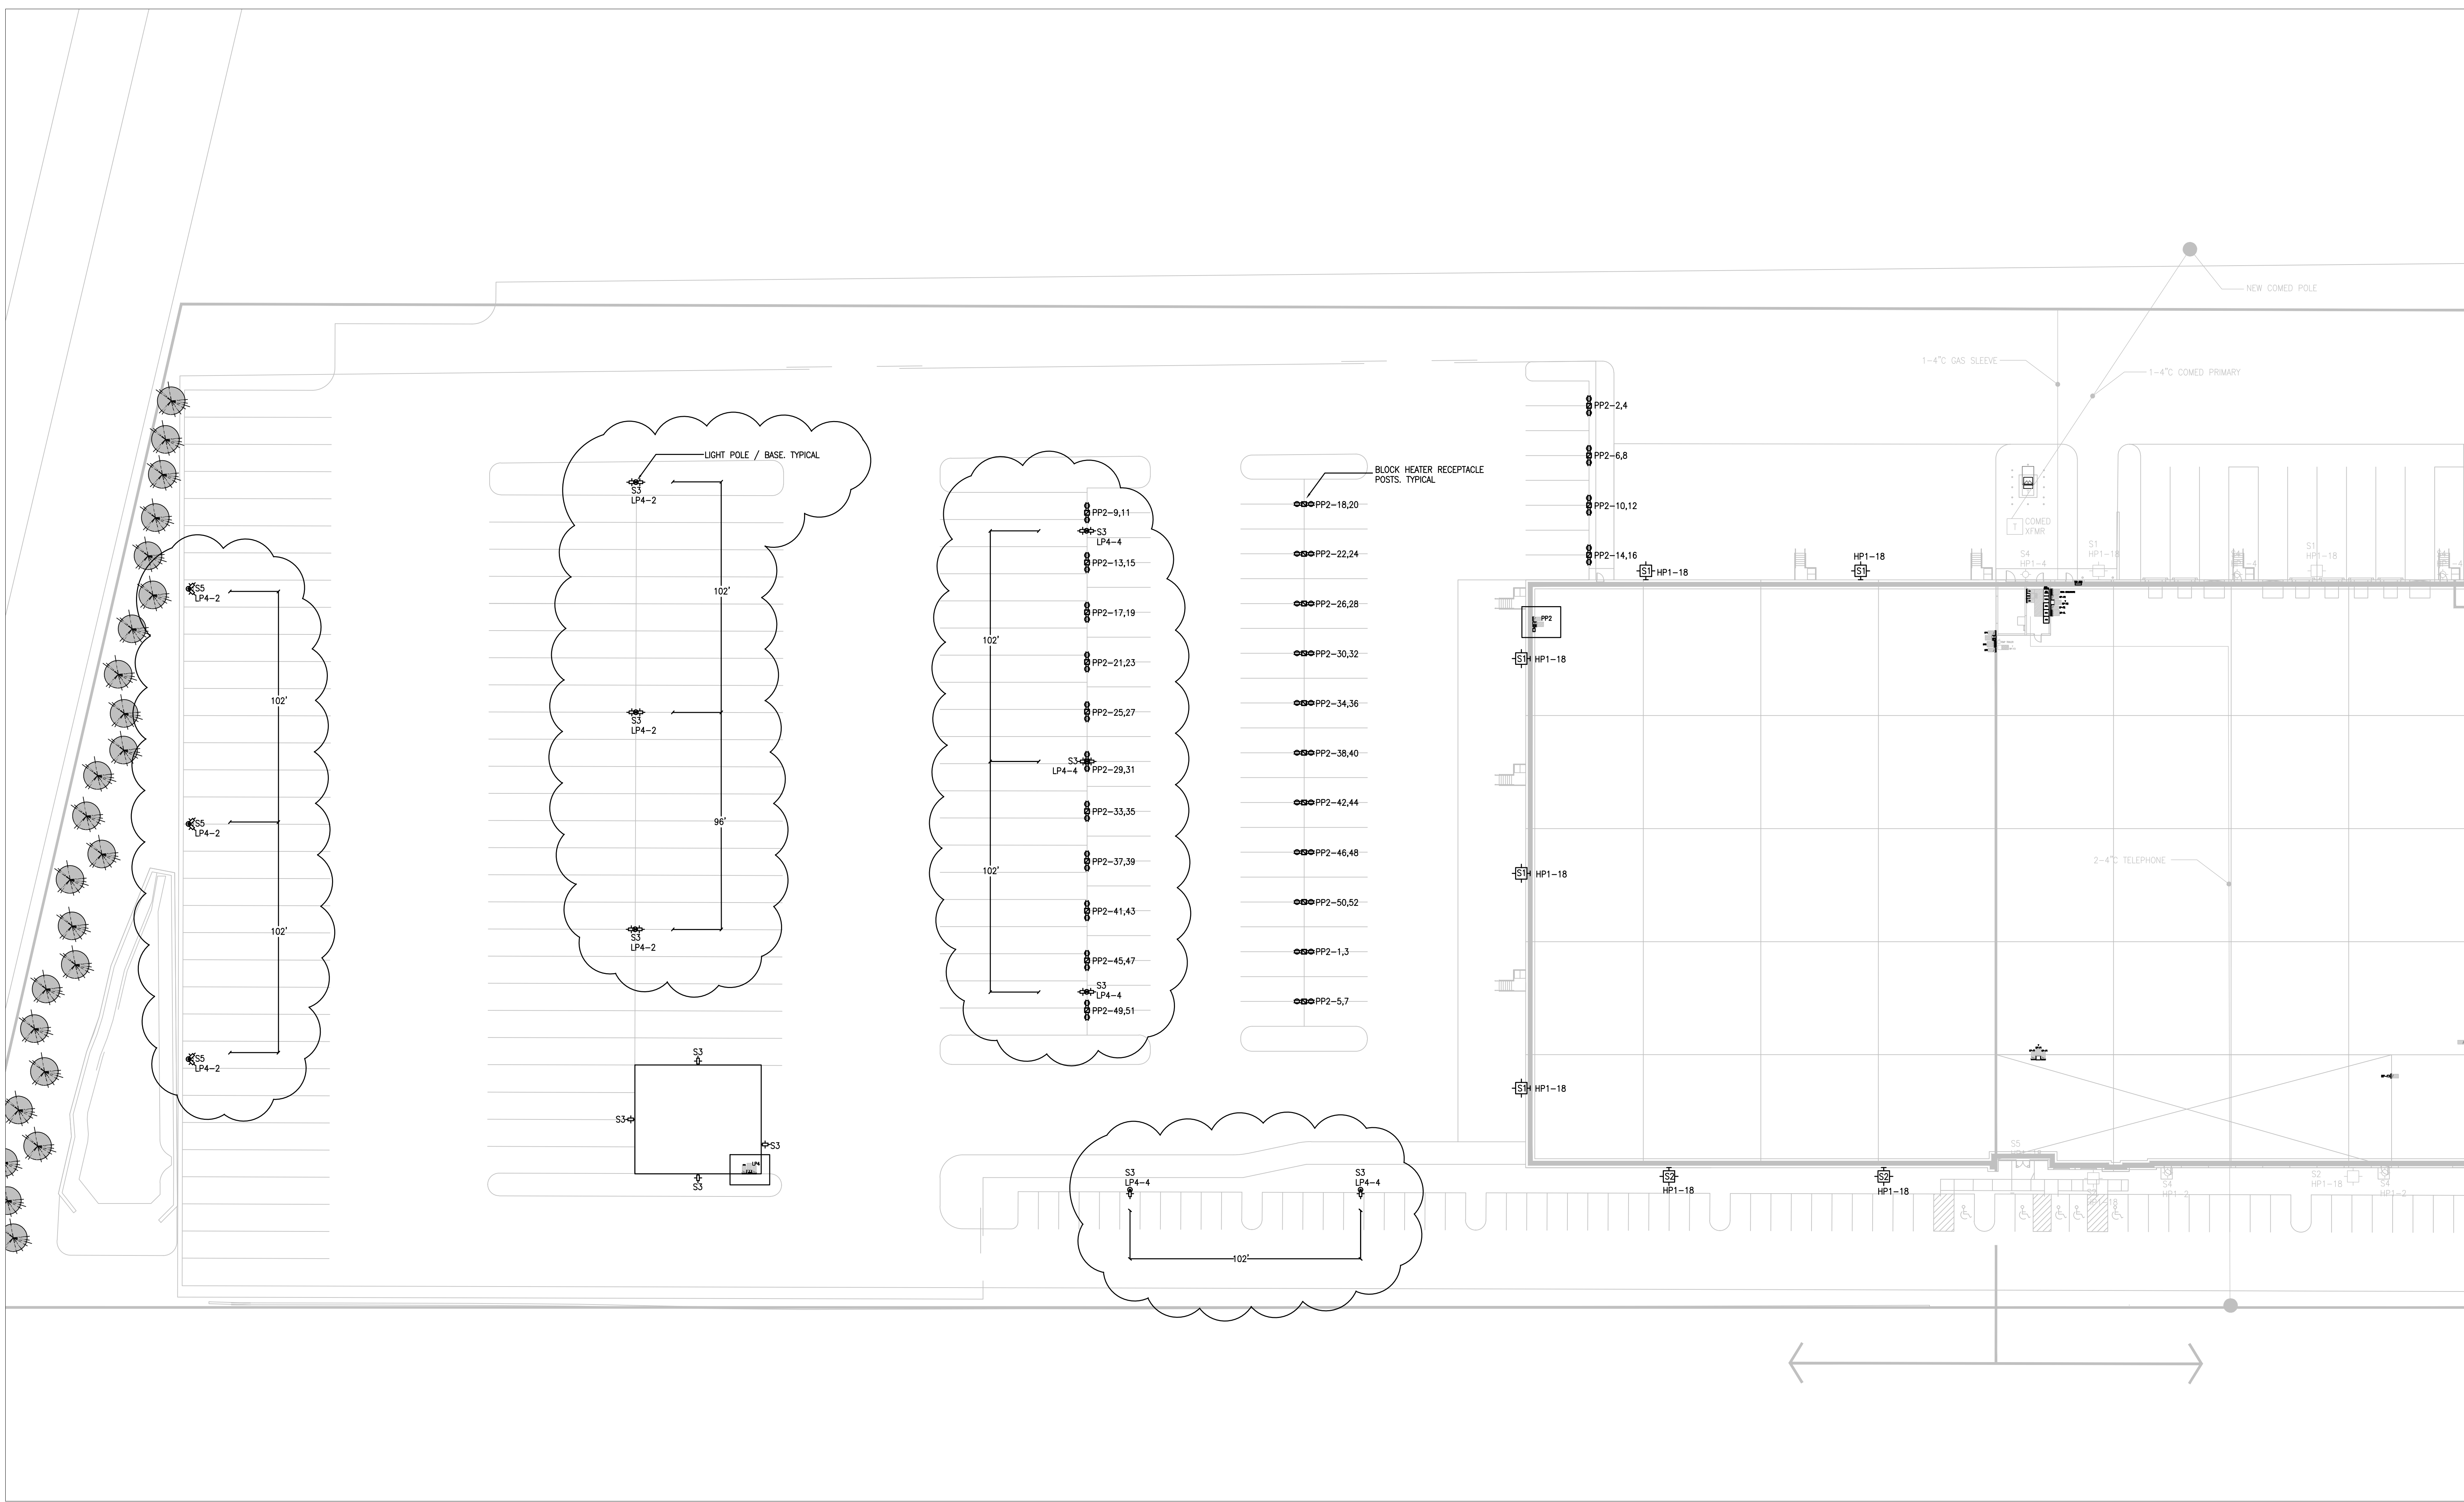

SITE LIGHTING PLAN

SCALE: 1"=30'

- NOTES:
- 4. ALL LIGHT FIXTURES TO BE FLAT BOTTOM, SHARP CUT-OFF.
 - 5. SITE LIGHTING TO BE PHOTOCELL ON / TIMECLOCK OFF.
 - 6. ALL WALL MOUNTED LIGHT FIXTURES TO BE MOUNTED 28' AFG.
 - 7. WALL MOUNT FIXTURES TO BE CENTER IN PRECAST PANELS. COORDINATE FINAL LOCATION AND HEIGHT WITH ARCHITECTURAL DRAWINGS.
 - 8. COORDINATE LIGHT POLE LOCATIONS WITH CIVIL.
 - 9. POLE BASES TO BE 4' ABOVE GRADE.
 - 10. ALL SITE LIGHTING TO BE 277V AND FED FROM MAINTENANCE BUILDING PANEL LP4.
 - 11. SEE DETAIL FOR BLOCK HEATER RECEPTACLE POSTS. VERIFY FINAL LOCATIONS.



REV.	DATE	PURPOSE	BY
2	02-04-21	ROUND 3 COMMENTS	MT
1	01-04-21	ISSUED FOR PERMIT	MT

REVISIONS

PROJECT INFORMATION:

FRITO LAY

703 WEST ALGONQUIN ROAD
UNIT 103
ARLINGTON HEIGHTS, IL 60005

DRAWING DESCRIPTION:

SITE LIGHTING PLAN



A DIVISION OF TRL COUNTY ELECTRIC
1143 N. MAIN STREET
LOMBARD, IL 60148
PH: 630-629-8050 FAX: 630-629-8089

SCALE: NA

JOB #:

DATE: 10-21-2020

HEC DRAWING #:

DRAFTER: MT

SE-100

ENGINEER:



SCALE: NA

NOTES:

1. CALCULATION POINTS ARE AT GROUND LEVEL.
2. ALL FIXTURE HEIGHTS ARE NOTED ON THE PLAN.
3. CALCULATION POINTS ARE ON A 10' x 10' SPACING.
4. CARS, SHROBBERY, EQUIPMENT AND SIGNAGE CAN CAUSE REDUCED LIGHT LEVELS FROM WHAT IS EXPECTED.
5. CALCULATIONS PROVIDED ARE NOT A GUARANTEE OF PERFORMANCE. ACTUAL LIGHT LEVELS MAY VARY.

***FIELD VERIFICATION REQUIRED.

- NOTES:
- ALL LIGHT FIXTURES TO BE FLAT BOTTOM, SHARP CUT-OFF.
 - SITE LIGHTING TO BE PHOTOCLOCK ON / TIMECLOCK OFF.
 - ALL WALL MOUNTED LIGHT FIXTURES TO BE MOUNTED 28" AFG.
 - WALL MOUNT FIXTURES TO BE CENTER IN PRECAST PANELS. COORDINATE FINAL LOCATION AND HEIGHT WITH ARCHITECTURAL DRAWINGS.
 - COORDINATE LIGHT POLE LOCATIONS WITH CIVIL.
 - POLE BASES TO BE 4' ABOVE GRADE.
 - ALL SITE LIGHTING TO BE 277V