
 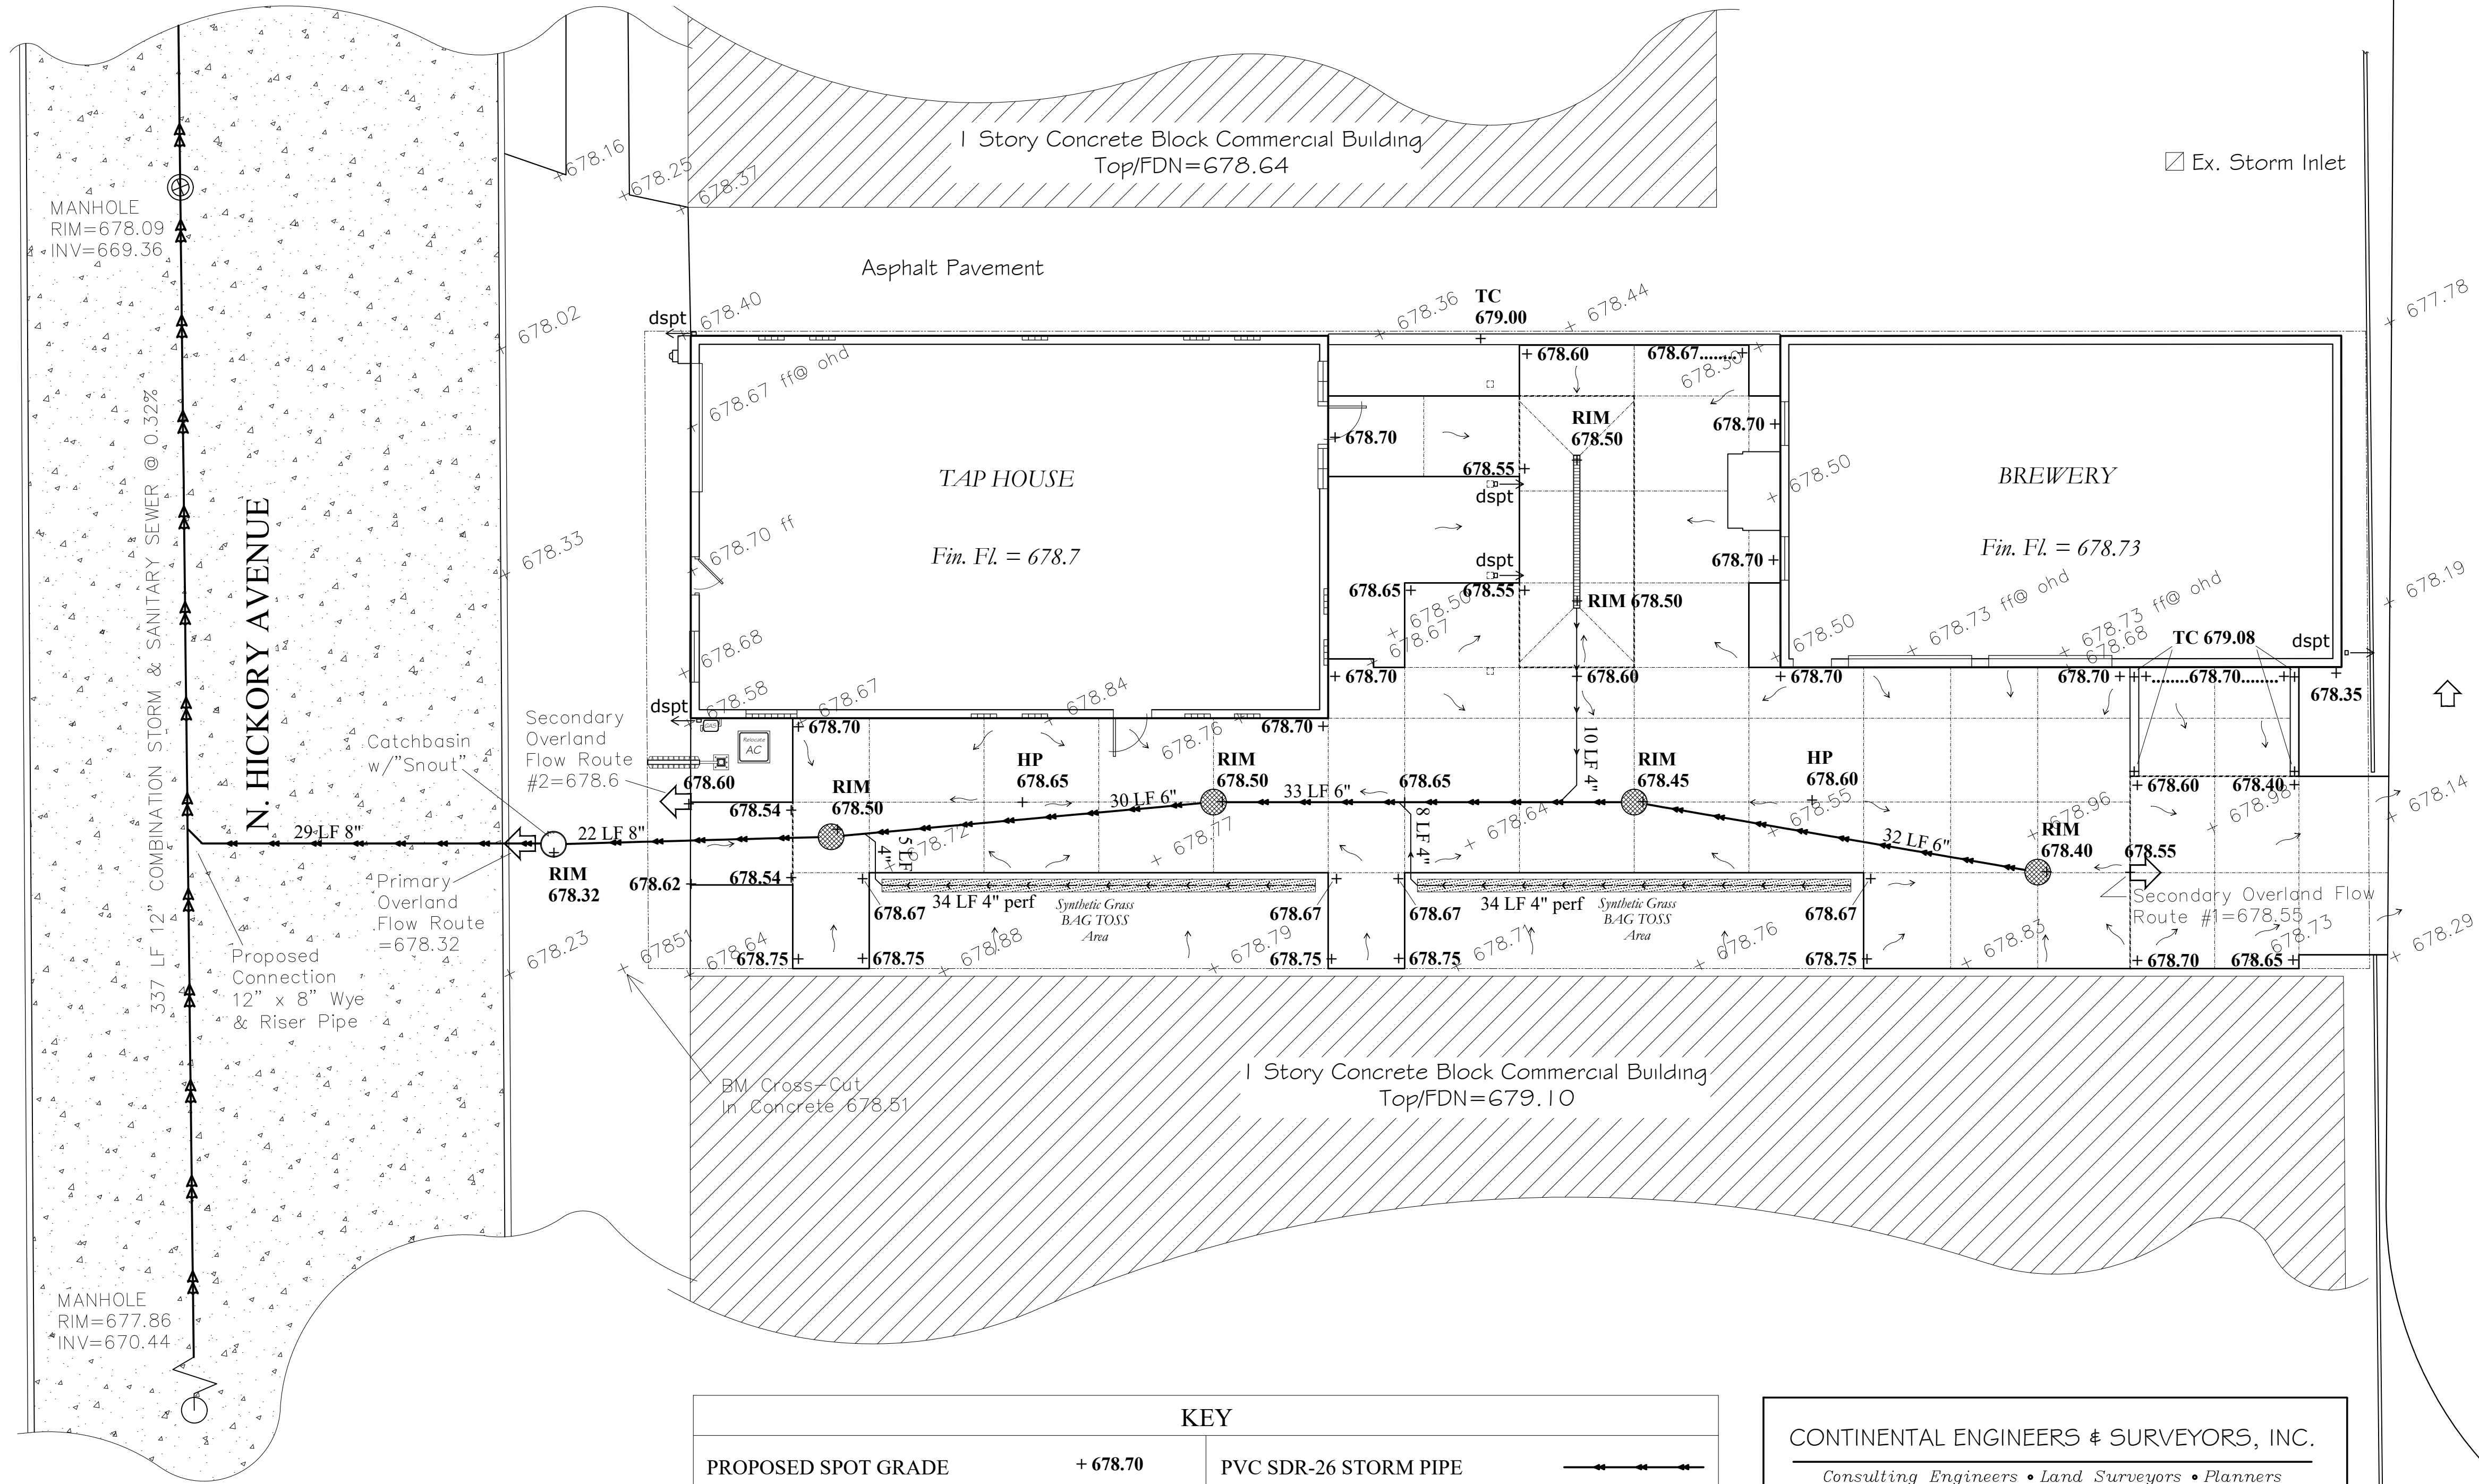


GRADING AND DRAINAGE CONCEPT PLAN
SCALE: 1" = 8'-0"



KEY			
PROPOSED SPOT GRADE	+ 678.70	PVC SDR-26 STORM PIPE (See Plan For Size)	
EXISTING SPOT GRADE	+ 678.71	4" PVC SDR-26 STORM PIPE	
PROPOSED INLET STRUCTURE		4" SCH-35 PERFORATED PVC PIPE FABRIC WRAPPED GRAVEL (installed below synthetic turf)	
CATCH BASIN w/ "Snout"		DIRECTION OF SURFACE FLOW	
PROPOSED 6" TRENCH DRAIN			

CONTINENTAL ENGINEERS & SURVEYORS, INC.
Consulting Engineers • Land Surveyors • Planners
Illinois Professional Design Firm #184-003402
1315 FAIRMONT ROAD, HOFFMAN ESTATES, ILLINOIS 60169
(847)885-3326 FAX:(847)885-3496

EXISTING TOPOGRAPHIC DATA PER
CONTINENTAL ENGINEERS AND SURVEYORS, INC.
PROJECT No. 19-119 DATED 6/3/19



Landscape Architects • Contractors • Wholesalers

2301 Winchester Road
P.O. Box 6810
Libertyville, IL 60048

847-949-5533 Fax 847-949-7154

Arlington
Beer
Company
19 N. Hickory Ave.
Arlington Heights
Illinois

PROJECT
Landscape Improvements
DRAWING NUMBER
LS-3
DRAWING TITLE
**Preliminary
Grading and Drainage Plan**
SHEET NUMBER

3 of 5
SCALE
1" = 8'-0"

DESIGNED/DRAWN BY

TRC/JAC

ISSUE	DESCRIPTION	DATE
#9	Submittal to Plan Commission	20.0608

THIS PLAN IS PROTECTED BY
COPYRIGHT. NO REPRODUCTION OR
USE IN WHOLE OR PART SHALL BE
MADE WITHOUT THE WRITTEN
CONSENT OF CARLSON LANDSCAPE
ASSOCIATES, INC. IN THE EVENT
THAT RIGHTS TO THE CONTENTS OF
THIS PLAN ARE RELEASED BY
CARLSON LANDSCAPE ASSOCIATES,
INC., THE SIGNATURE BLOCK BELOW
WILL BE COMPLETE AND CARRY THE
CORPORATE SEAL.

LANDSCAPE ARCHITECT

DATE

LS-3

