

GROUP Architects/builder
A Professional Corporation
415 West Golf Rd., Suite 6
Arlington Heights, IL 60005

Phone: 847.952.1100
Fax: 847.952.1155
Web: www.grouparch.com

PROFESSIONAL & MEDICAL
OFFICE - SUITE 2
131 W. RAND ROAD
ARLINGTON HEIGHTS, IL.

SIGNATURE AND SEAL

[illegible]

COPYRIGHT 2008
THESE DOCUMENTS AND THEIR CONTENTS
ARE THE SOLE PROPERTY OF BRUCE A.
ARCHITECTS, INC. AND ARE ISSUED ONLY
FOR THE SPECIFIC PROJECT WITHIN ANY
REPRODUCTION, REVISION, OR ALTERATION
OF THESE DOCUMENTS WITHOUT THE WRITTEN
CONSENT OF BRUCE A. ARCHITECTS, INC. IS PROHIBITED BY LAW.

DRAWN BY _____

CHECKED BY	RW
------------	----

APPROVED BY	JOB NUMBER
-------------	------------

DRAWING TITLE 09.0777

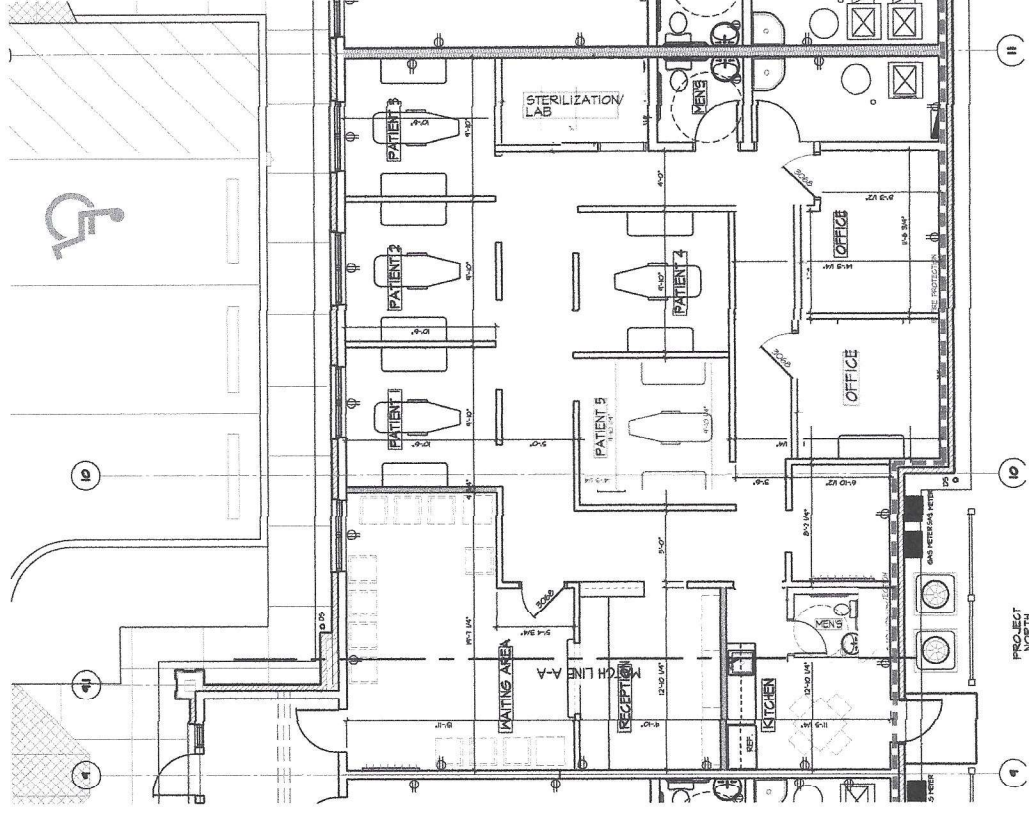
SUITE 2
FLOOR PLAN

DRAWING NUMBER
A101

A1.01

1	30 AMP ELECTRICAL INVERT BRIDGE	5	4 CONCRETE BATTAL OVER 4 PMS
2	ELECTRIC PANEL, USE ELECTRICAL WIRING FOR DETAILS	6	STEP IN WOOD 1/2 INCHES, USE 4x4x8
3	4x4x8 TUBES TO SUPPORT SUPP PUMP	7	3/4" GALV CLEAR ROD, FINISH 6x4
4	AIR CONDITION UNIT	8	WOOD SET IN CONCRETE
		9	1/4" DRIP 5/8x1/4
		10	1/4" DRIP 3/4x1/4 ROOF

TOTAL OCCUPANCY OF FOUR (4) PEOPLE,
ONE (1) SHARED TOILET REQUIREMENT

PROJECT
NORTH

SUITE 2 FLOOR PLAN

SCALE: 1/4" = 1'-0"

S & ELEC. LEGEND													
SECTION		3-2 AIR RETURN REGISTER		IMPERF DUCT		THREE-2 FAN/FA		8-24 FLOOR AND 8-24 FLOOR AND		POWERS' SIGN		CONNECTION TO THE MAIN	
RECP		SINGLE RECEPT		IMPERF DUCT		THREE-2 FAN/FA		8-24 FLOOR AND 8-24 FLOOR AND		POWERS' SIGN		CONNECTION TO THE MAIN	
		Z		IMPERF DUCT		THREE-2 FAN/FA		8-24 FLOOR AND 8-24 FLOOR AND		POWERS' SIGN		CONNECTION TO THE MAIN	
		Z		IMPERF DUCT		THREE-2 FAN/FA		8-24 FLOOR AND 8-24 FLOOR AND		POWERS' SIGN		CONNECTION TO THE MAIN	
		Z		IMPERF DUCT		THREE-2 FAN/FA		8-24 FLOOR AND 8-24 FLOOR AND					

ATOR TO PROVIDE ALL ELECTRICAL OUTLETS AS SHOWN, SWITCHING, LIGHTS, AND GRID, AND ALL EMERGENCY EXITING REQUIREMENTS BY FUTURE TENANT (OUT UNDER SEPARATE PERMIT)

