

T: 312.464.1444
www.strpartners.com

- CONCRETE ENGINEERING**
CRACKS ENGINEERING ASSOCIATES, LTD.
145 Commerce Drive, Suite A
Lansdale, PA 19030
(617) 223-4504
- LANDSCAPE ARCHITECTURE**
ERIKSKOEN ENGINEERING ASSOCIATES, LTD.
145 Commerce Drive, Suite A
Rykrick, NJ 06030
(617) 223-4804
- GENERAL BUILDING RESOURCES LLC**
STR-SEG/ST BUILDING RESOURCES LLC
350 West Ontario Street, Suite 200
Chicago, IL 60654
(262) 253-4700
- STRUCTURAL ENGINEERS**
THE STRUCTURAL GROUP
707 Lake Cook Road, Suite 300
Deerfield, IL 60015
(847) 981-1880
- ME/ET ENGINEERS**
C&S DESIGN GROUP LLC
837 Oakton Street
Eli Grove Village, IL 60007
(847) 891-1880
- ENGINEERS**
NICHOLAS & ASSOCIATES
1001 Fearnheadville Drive
Mount Prospect, IL 60056
(847) 394-6205

KEY PLAN

SCOPE DOCUMENT

This drawing is one drawing within a complete set of documents and shall not be considered separately from the Drawings as a whole. The Drawings indicate the general scope of the project in terms of architectural design concept, the dimensions of the building, the major architectural elements and the type of structural, mechanical, and electrical systems. As Scope Documents, the Drawings do not necessarily indicate or describe all work required for full performance and completion of the requirements of the Construction Documents. On the basis of the general scope indicated or described, the Contractor shall furnish all items required for the proper execution and completion of the Work.

Copyright Notice, Copyright © 2023 STR PARTNERS, LLC
The information in this document is the intellectual property of STR Partners, LLC. It is intended solely for use by the "Client" during only this specific project. Reproduction of any portion of this document for any purpose other than for its intended use is not permitted without specific written permission of STR Partners, LLC.

PROJECT

**OLIVE-MARY STITT
ELEMENTARY SCHOOL
ADDITION**

Arlington Heights, IL 60004

**ARLINGTON HEIGHTS
SCHOOL DISTRICT 25**
1200 South Dunton Avenue
Arlington Heights, IL 60005

CLIENT PROJECT NUMBER

STR PROJECT NUMBER

22050

DRAWING DATES

NUMBER	DATE	COMMENTS
--------	------	----------

•

•

1

•

•

- 1 JAN. 20, 2023 ISSUE FOR PLAN COMMISSION

DRAWING TITLE

PHOTOMETRIC PLAN

SHEET NUMBER

PH0.0


TYPE	DESCRIPTION	MOUNTING	LAMPS	VOLTAGE	MANUFACTURER & CATALOG NUMBER	ACCEPTABLE MANUFACTURER
W1	ARCHITECTURAL EXTERIOR WALL MOUNTED LUMINAIRE WITH TYPE 4 DISTRIBUTION, DARK ANODIZED FINISH, AND INTERNAL MOTION SENSOR CONTROLS	MOUNTED Ø 10"Ø A.F.G.	L.E.D. 23 WATT 5000K	120VOLT	DISNEY LED 300 300 FOR 14M 120VOLT FPM C08D0	LITHONIA EQUALE

Statistics

Description	Symbol	Avg	Max	Min	Max/Min	Avg/Min
Calc Zone #1	+	0.7 fc	4.5 fc	0.0 fc	N/A	N/A


Luminaire Locations

Location						
No.	Label	X	Y	MH	Orientation	Tilt
2	W1	203.50	386.50	9.00	270.00	0.00
3	W1	194.75	413.00	9.00	270.00	0.00
4	W1	194.75	445.00	9.00	270.00	0.00
5	W1	190.50	480.25	9.00	270.00	0.00
6	W1	227.25	496.25	10.00	0.00	0.00
1	W1	221.75	368.75	9.00	180.00	0.00

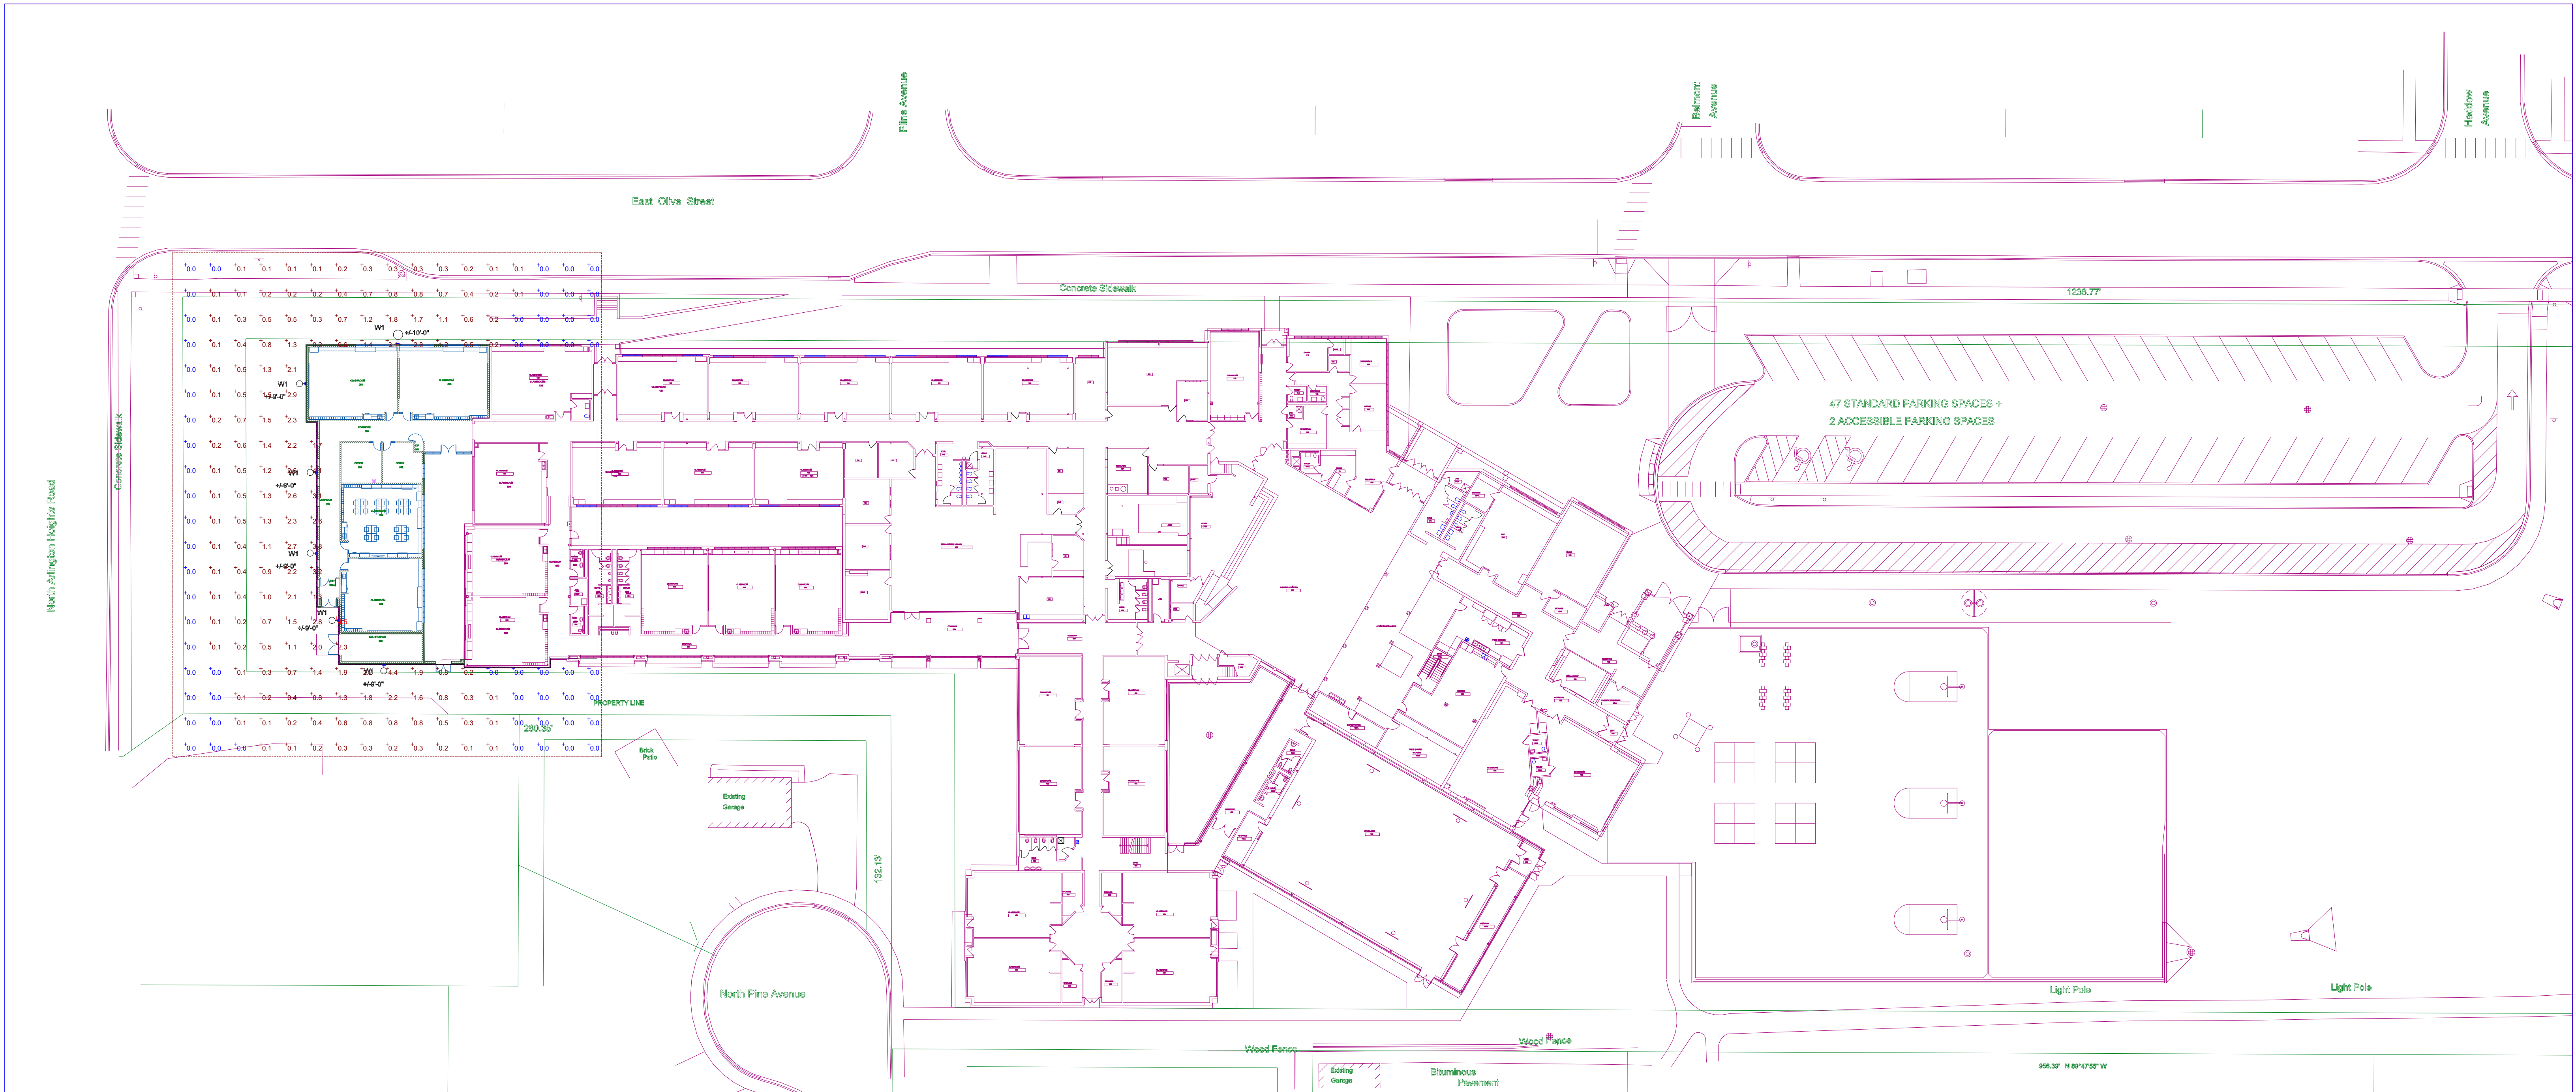

SITE PLAN - ELECTRICAL

 SCALE: 1" = 30'



IN-PROGRESS
NOT FOR CONSTRUCTION
1/20/23